


Eastern Mechanical Services, Inc.
 3 Starr Street
 Danbury, CT 06810
 203.792.7668

www.emsinc.us

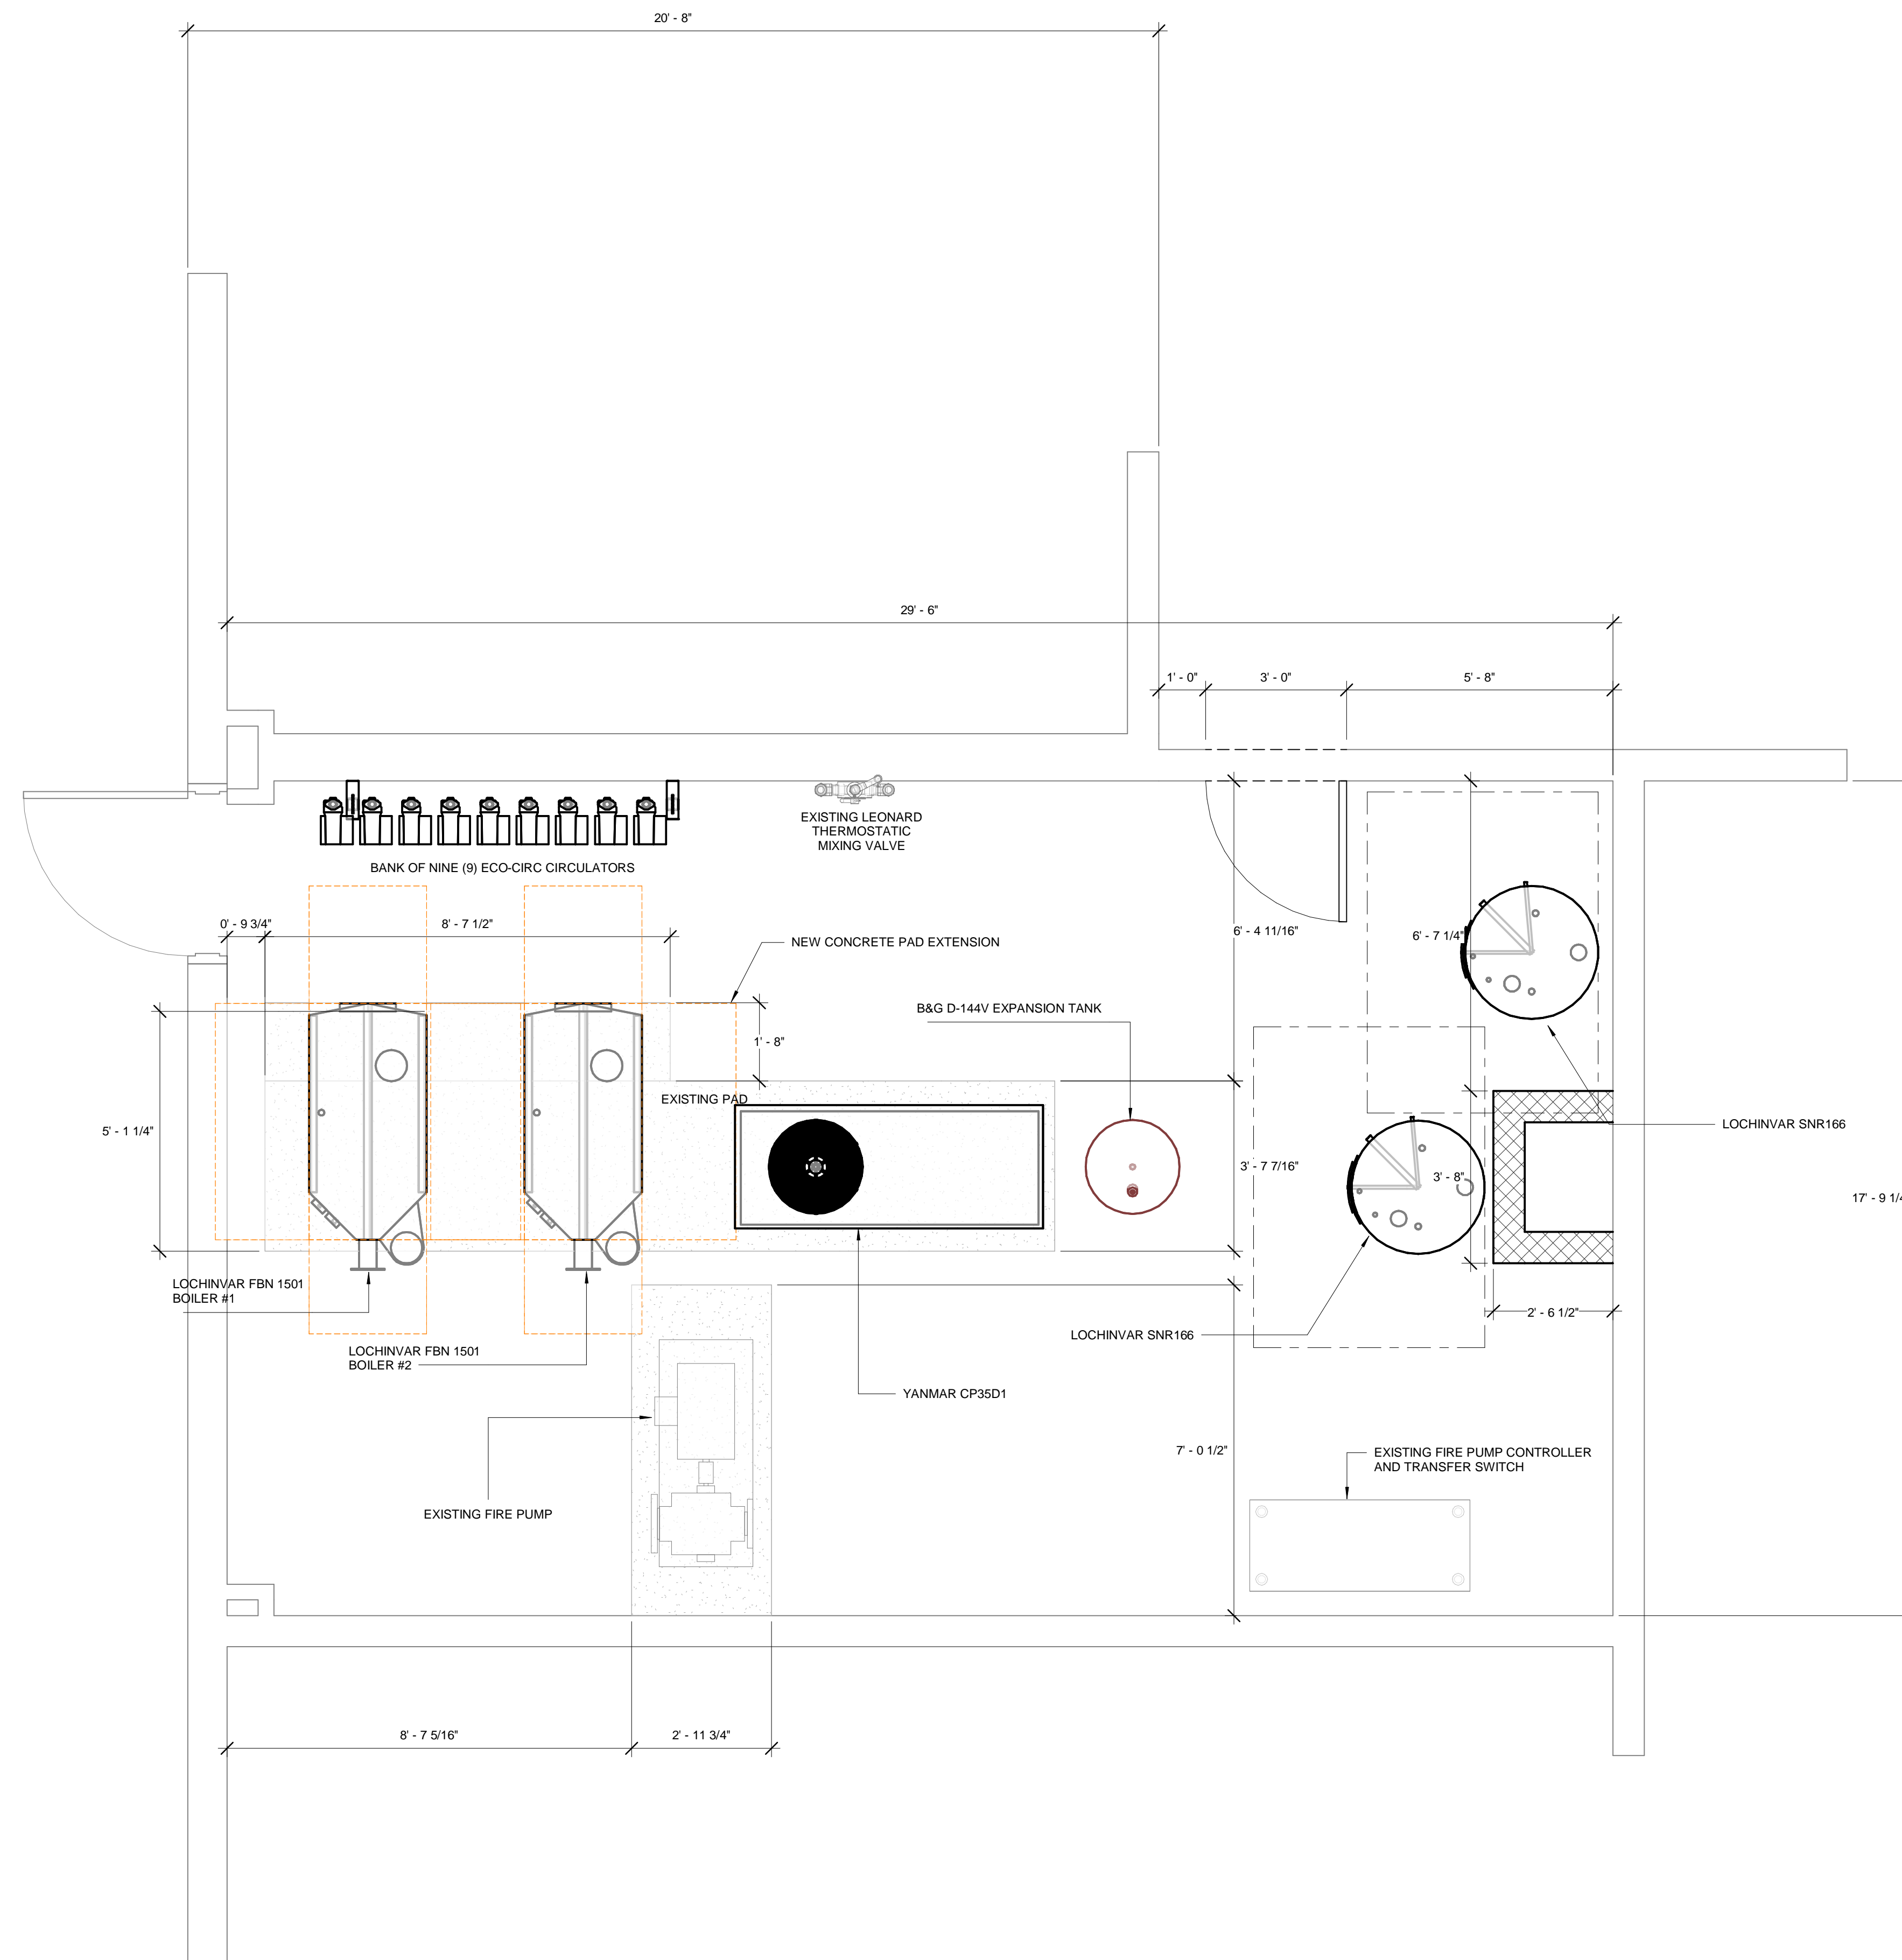

1 - ARCH
 1/2" = 1'-0"

No.	Description	Date


BRIDGEPORT RESCUE MISSION, INC.
 JOEL SMILOW CARE CENTER
 725 PARK AVENUE
 BRIDGEPORT, CT

BOILER ROOM PLAN

Project Number	4929
Date	9/23/19
Drawn By	T.H.
Checked By	S.C.


A100.0
 Scale 1/2" = 1'-0"

10/1/2019 10:00:11 AM

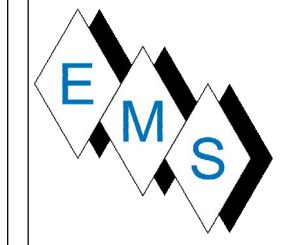

Eastern Mechanical Services, Inc.
3 Starr Street
Danbury, CT 06810
203.792.7668

www.emsinc.us

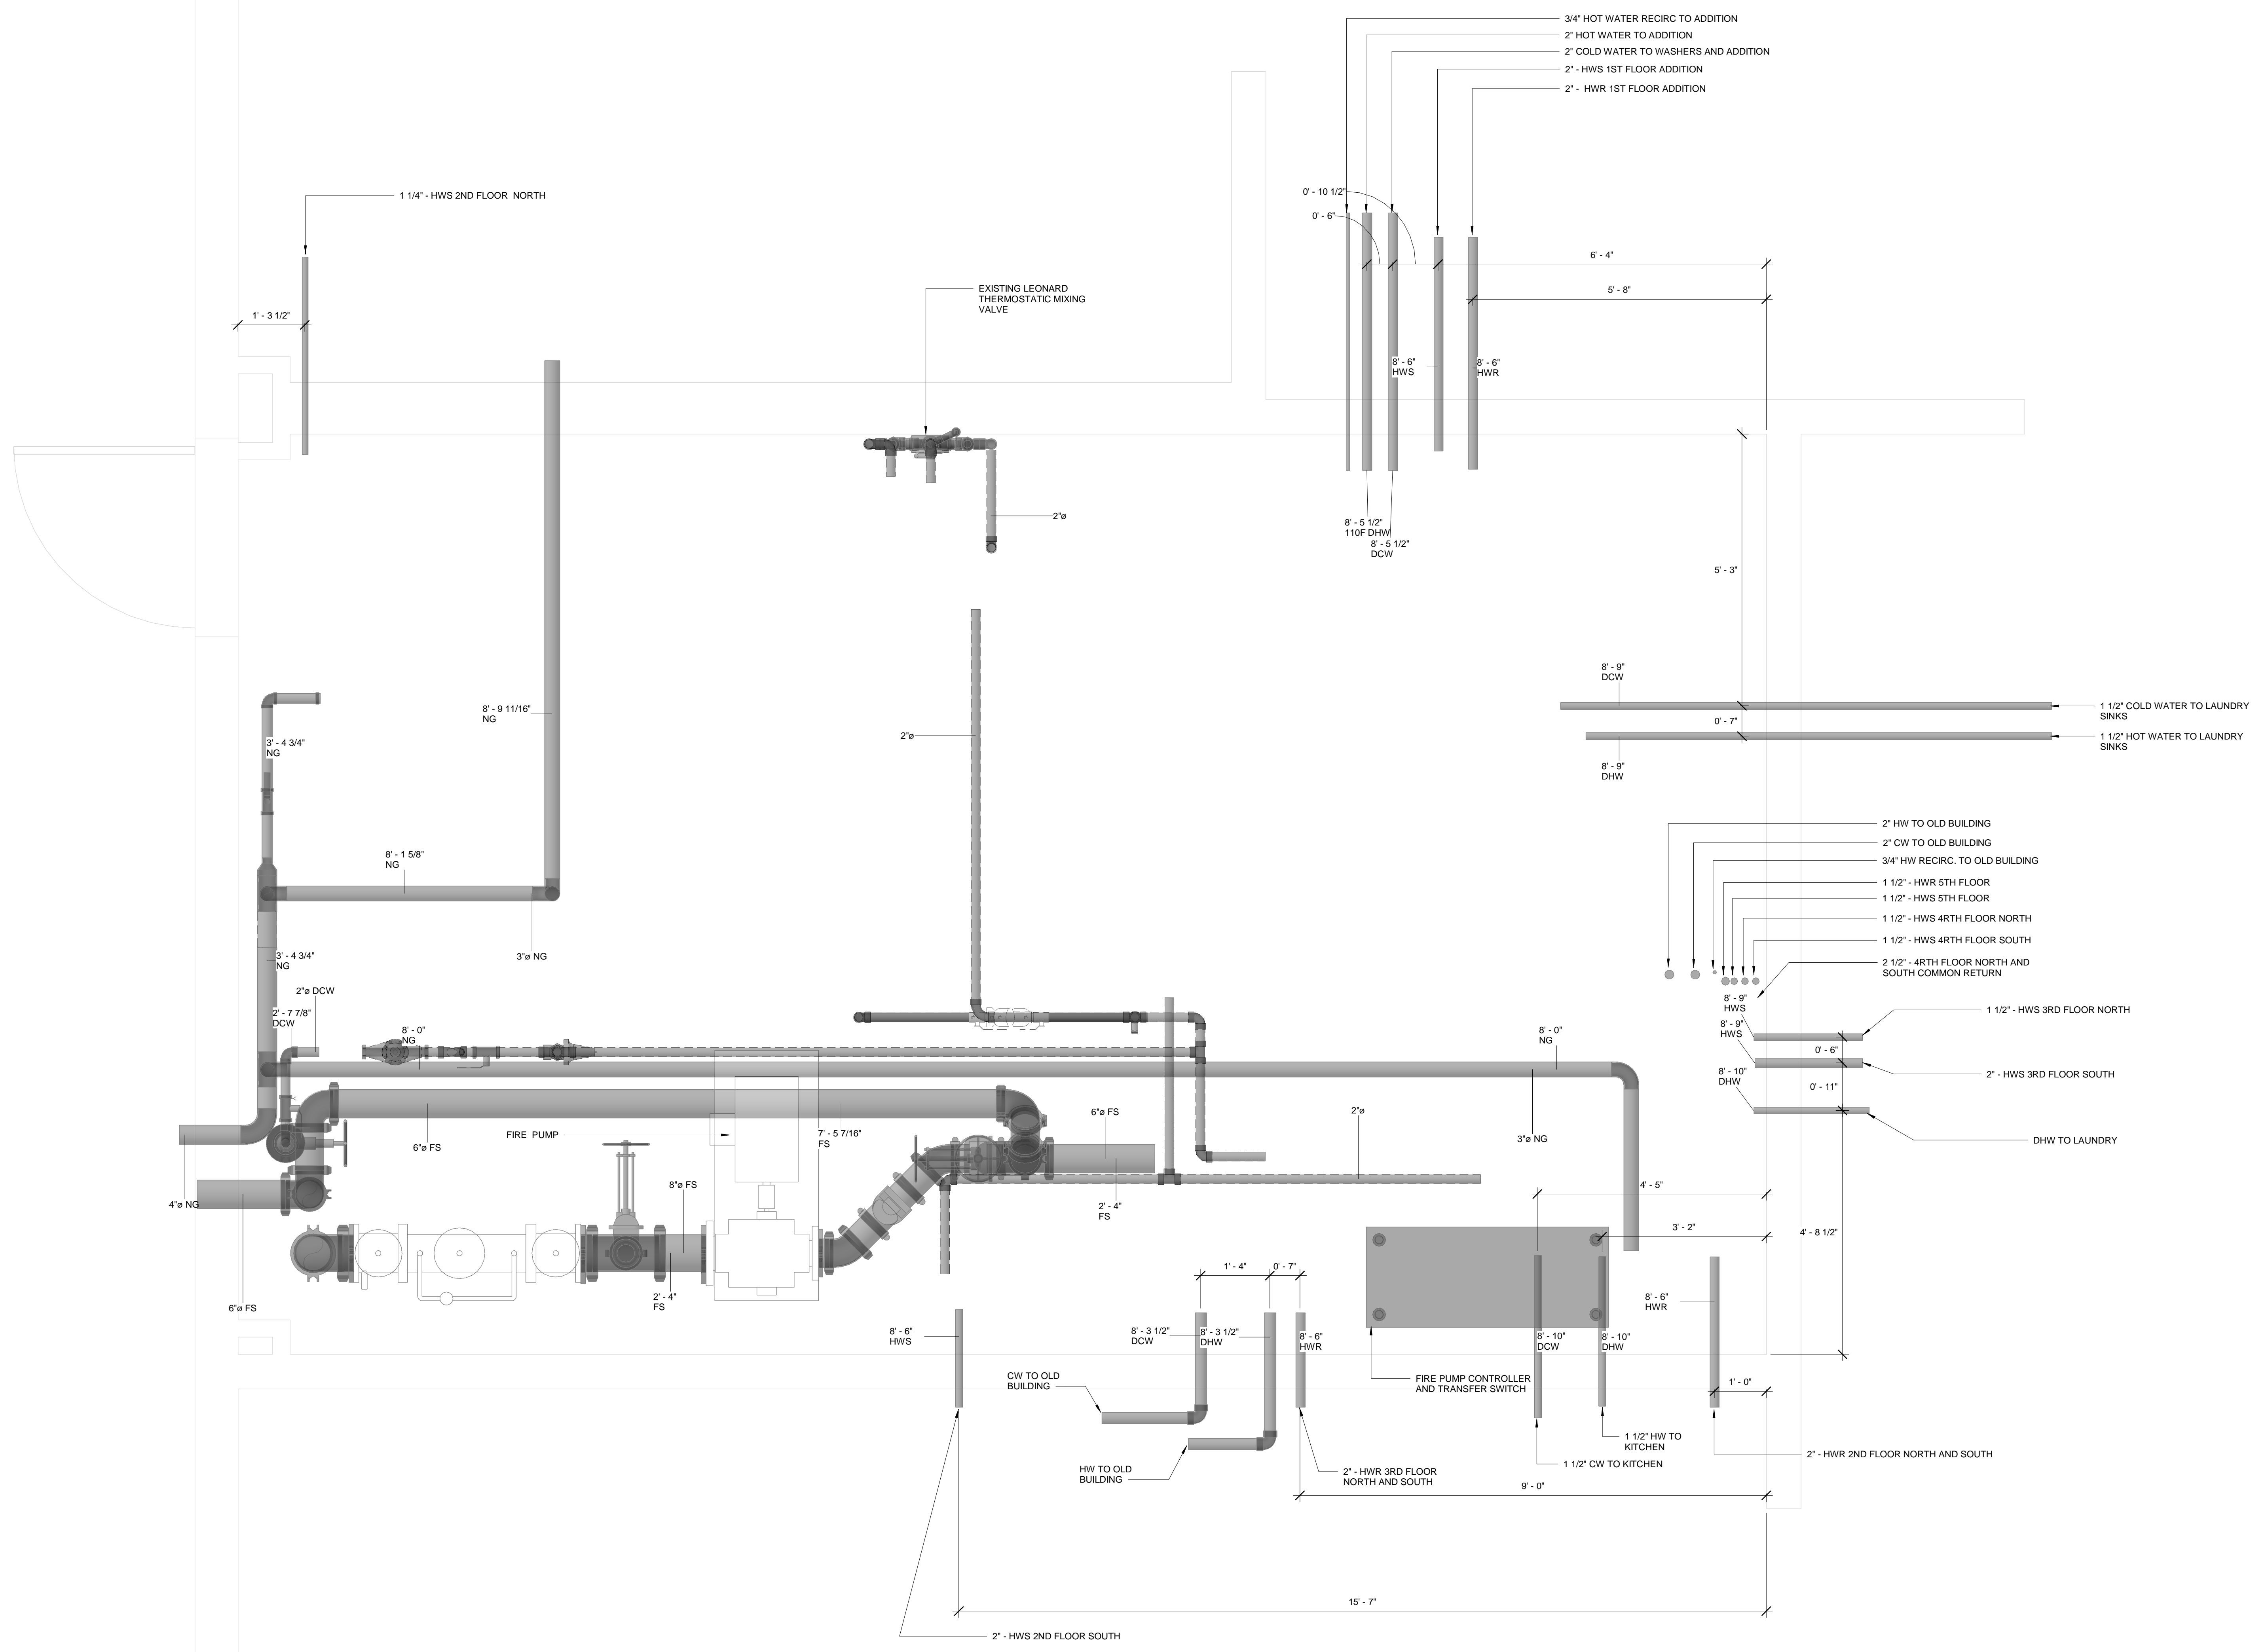

No.	Description	Date

BRIDGEPORT RESCUE MISSION, INC.

JOEL SMILOW CARE CENTER

**725 PARK AVENUE
BRIDGEPORT, CT**

EXISTING BOILER MECHANICAL PLAN


Project Number	4929
Date	9/23/19
Drawn By	T.H.
Checked By	T.H.

M100.0

Scale 3/4" = 1'-0"


EXISTING BOILER ROOM MECHANICAL
PLAN
3/4" = 1'-0"

10/11/2019 10:09:55 AM

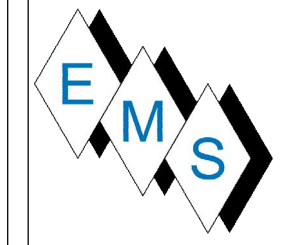

Eastern Mechanical Services, Inc.
 3 Starr Street
 Danbury, CT 06810
 203.792.7668

www.emsinc.us

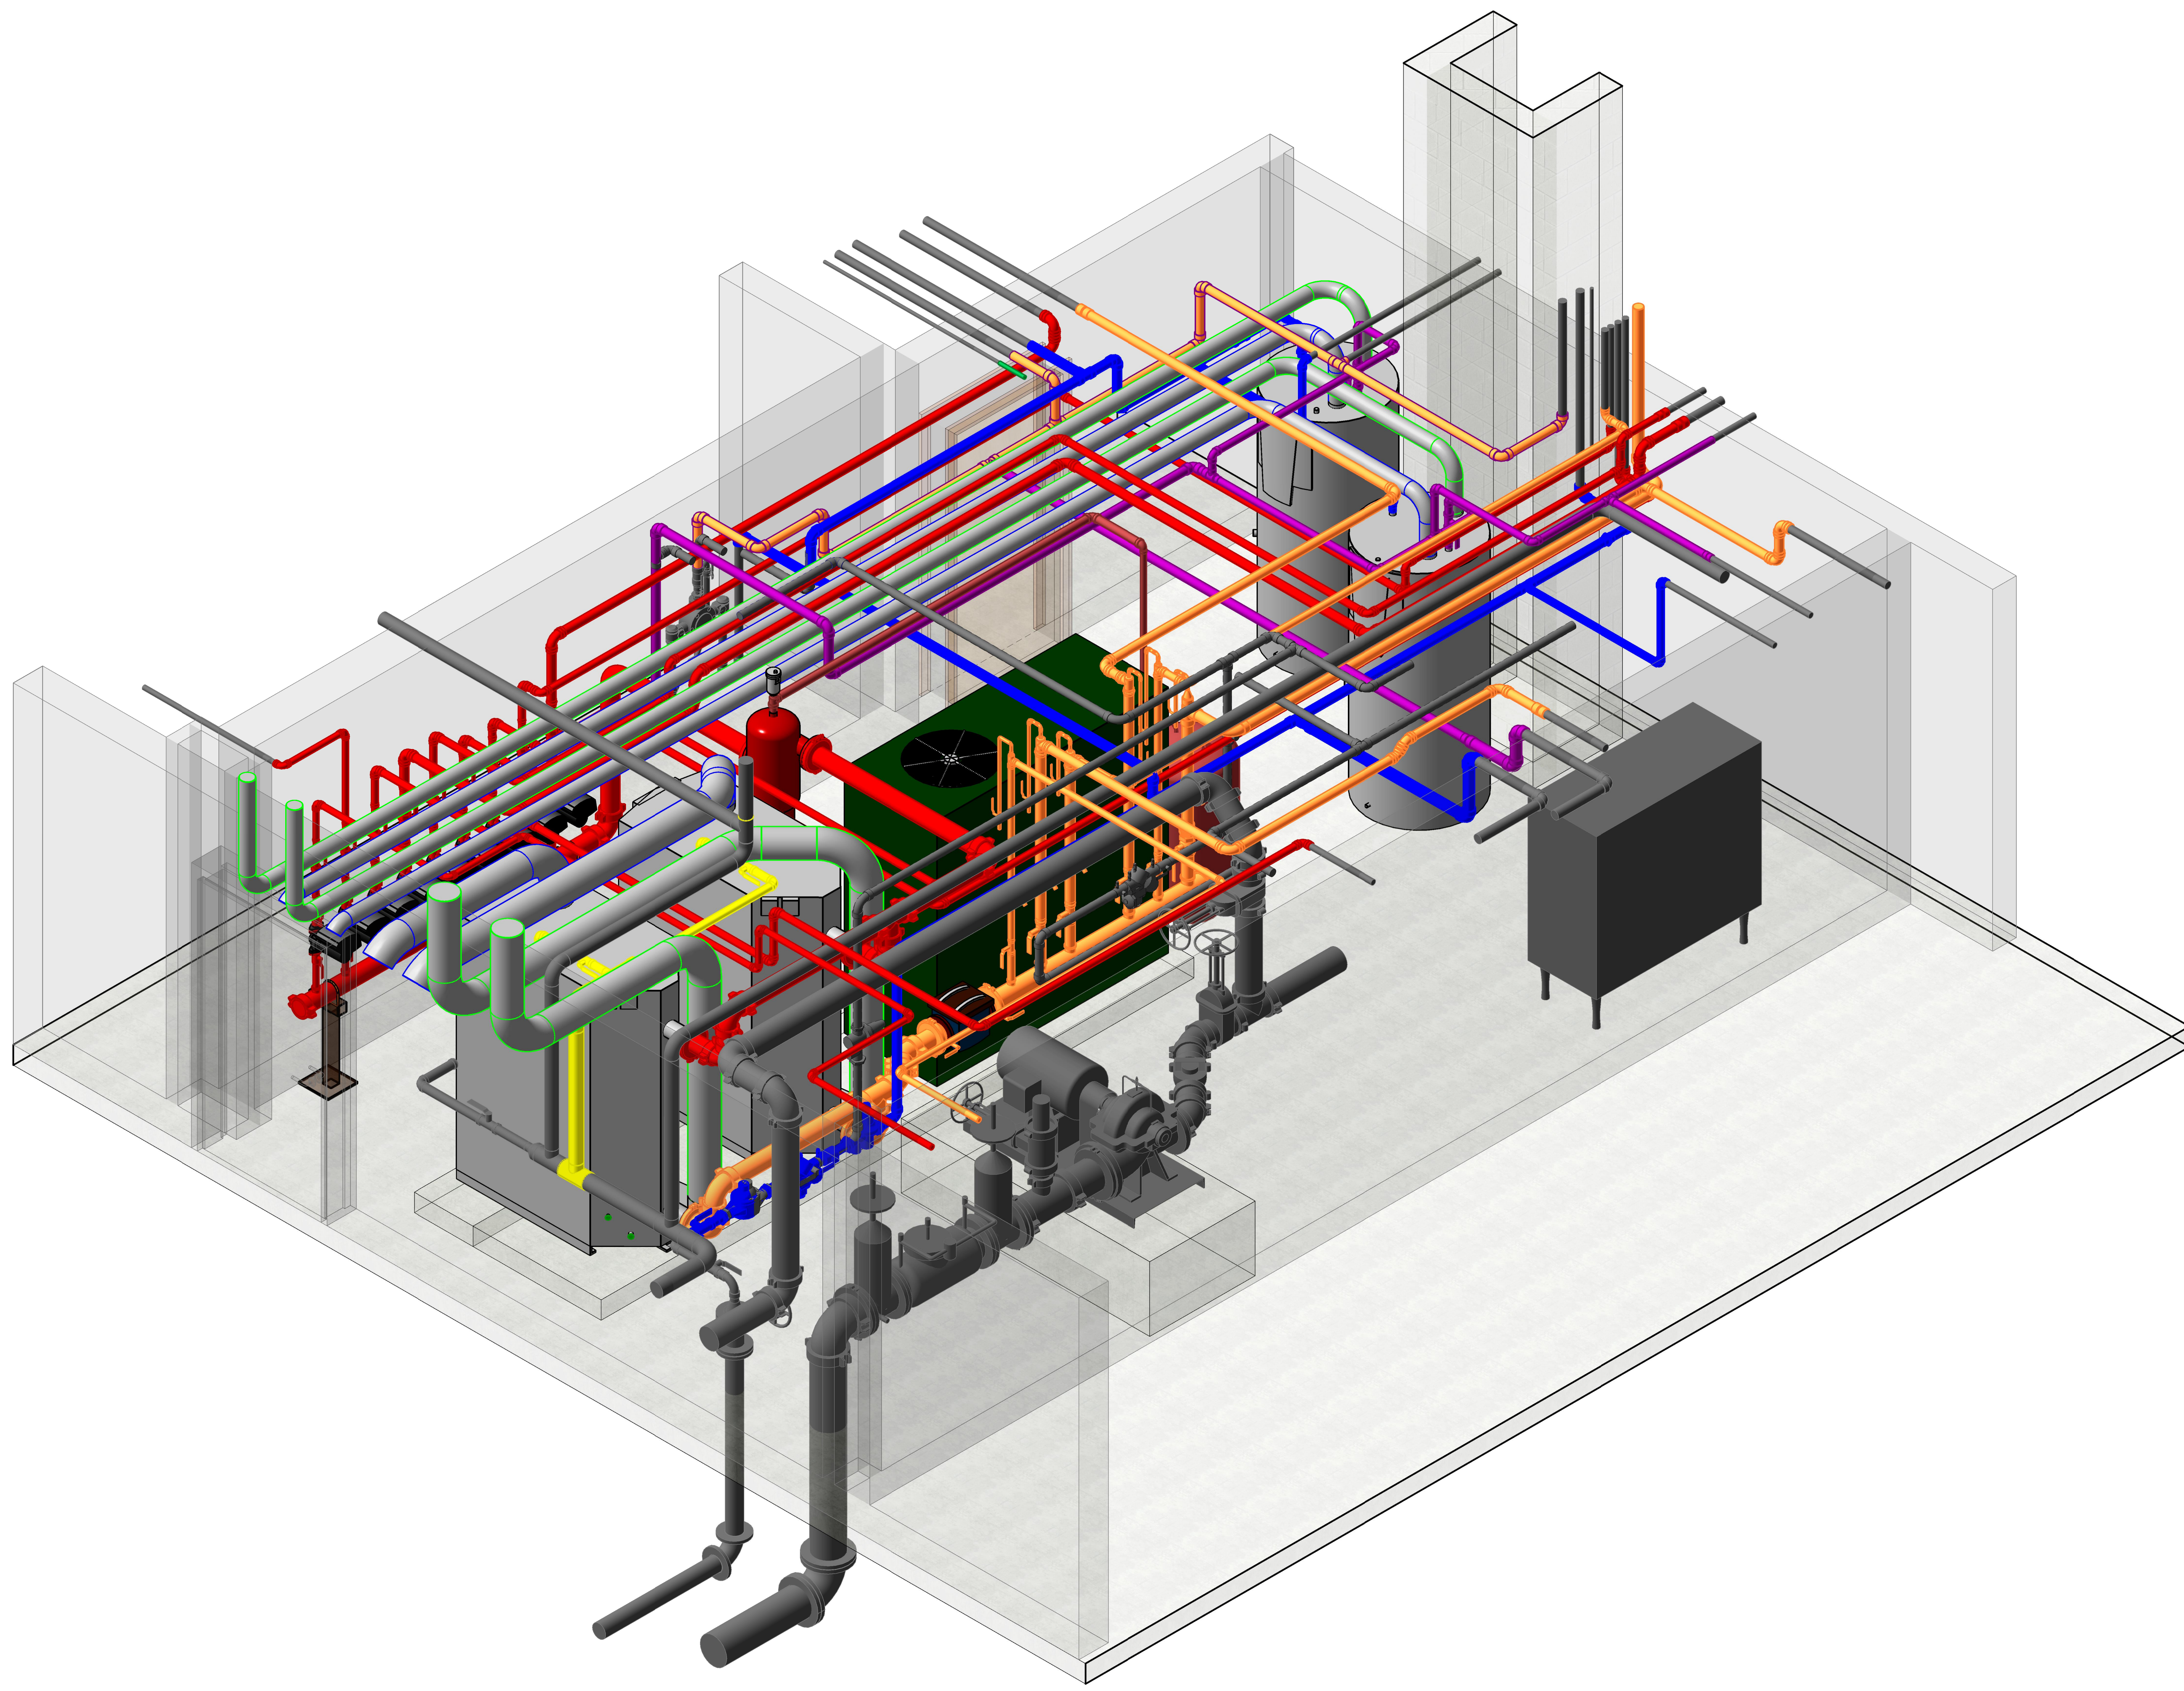

No.	Description	Date

BRIDGEPORT RESCUE MISSION,
 INC.

JOEL SMILOW CARE CENTER

725 PARK AVENUE
 BRIDGEPORT, CT

BOILER ROOM ISO



Project Number	4929
Date	9/23/19
Drawn By	T.H.
Checked By	T.H.

M100.1

Scale

1 DRAWING 3D VIEW

10/1/2019 9:56:24 AM

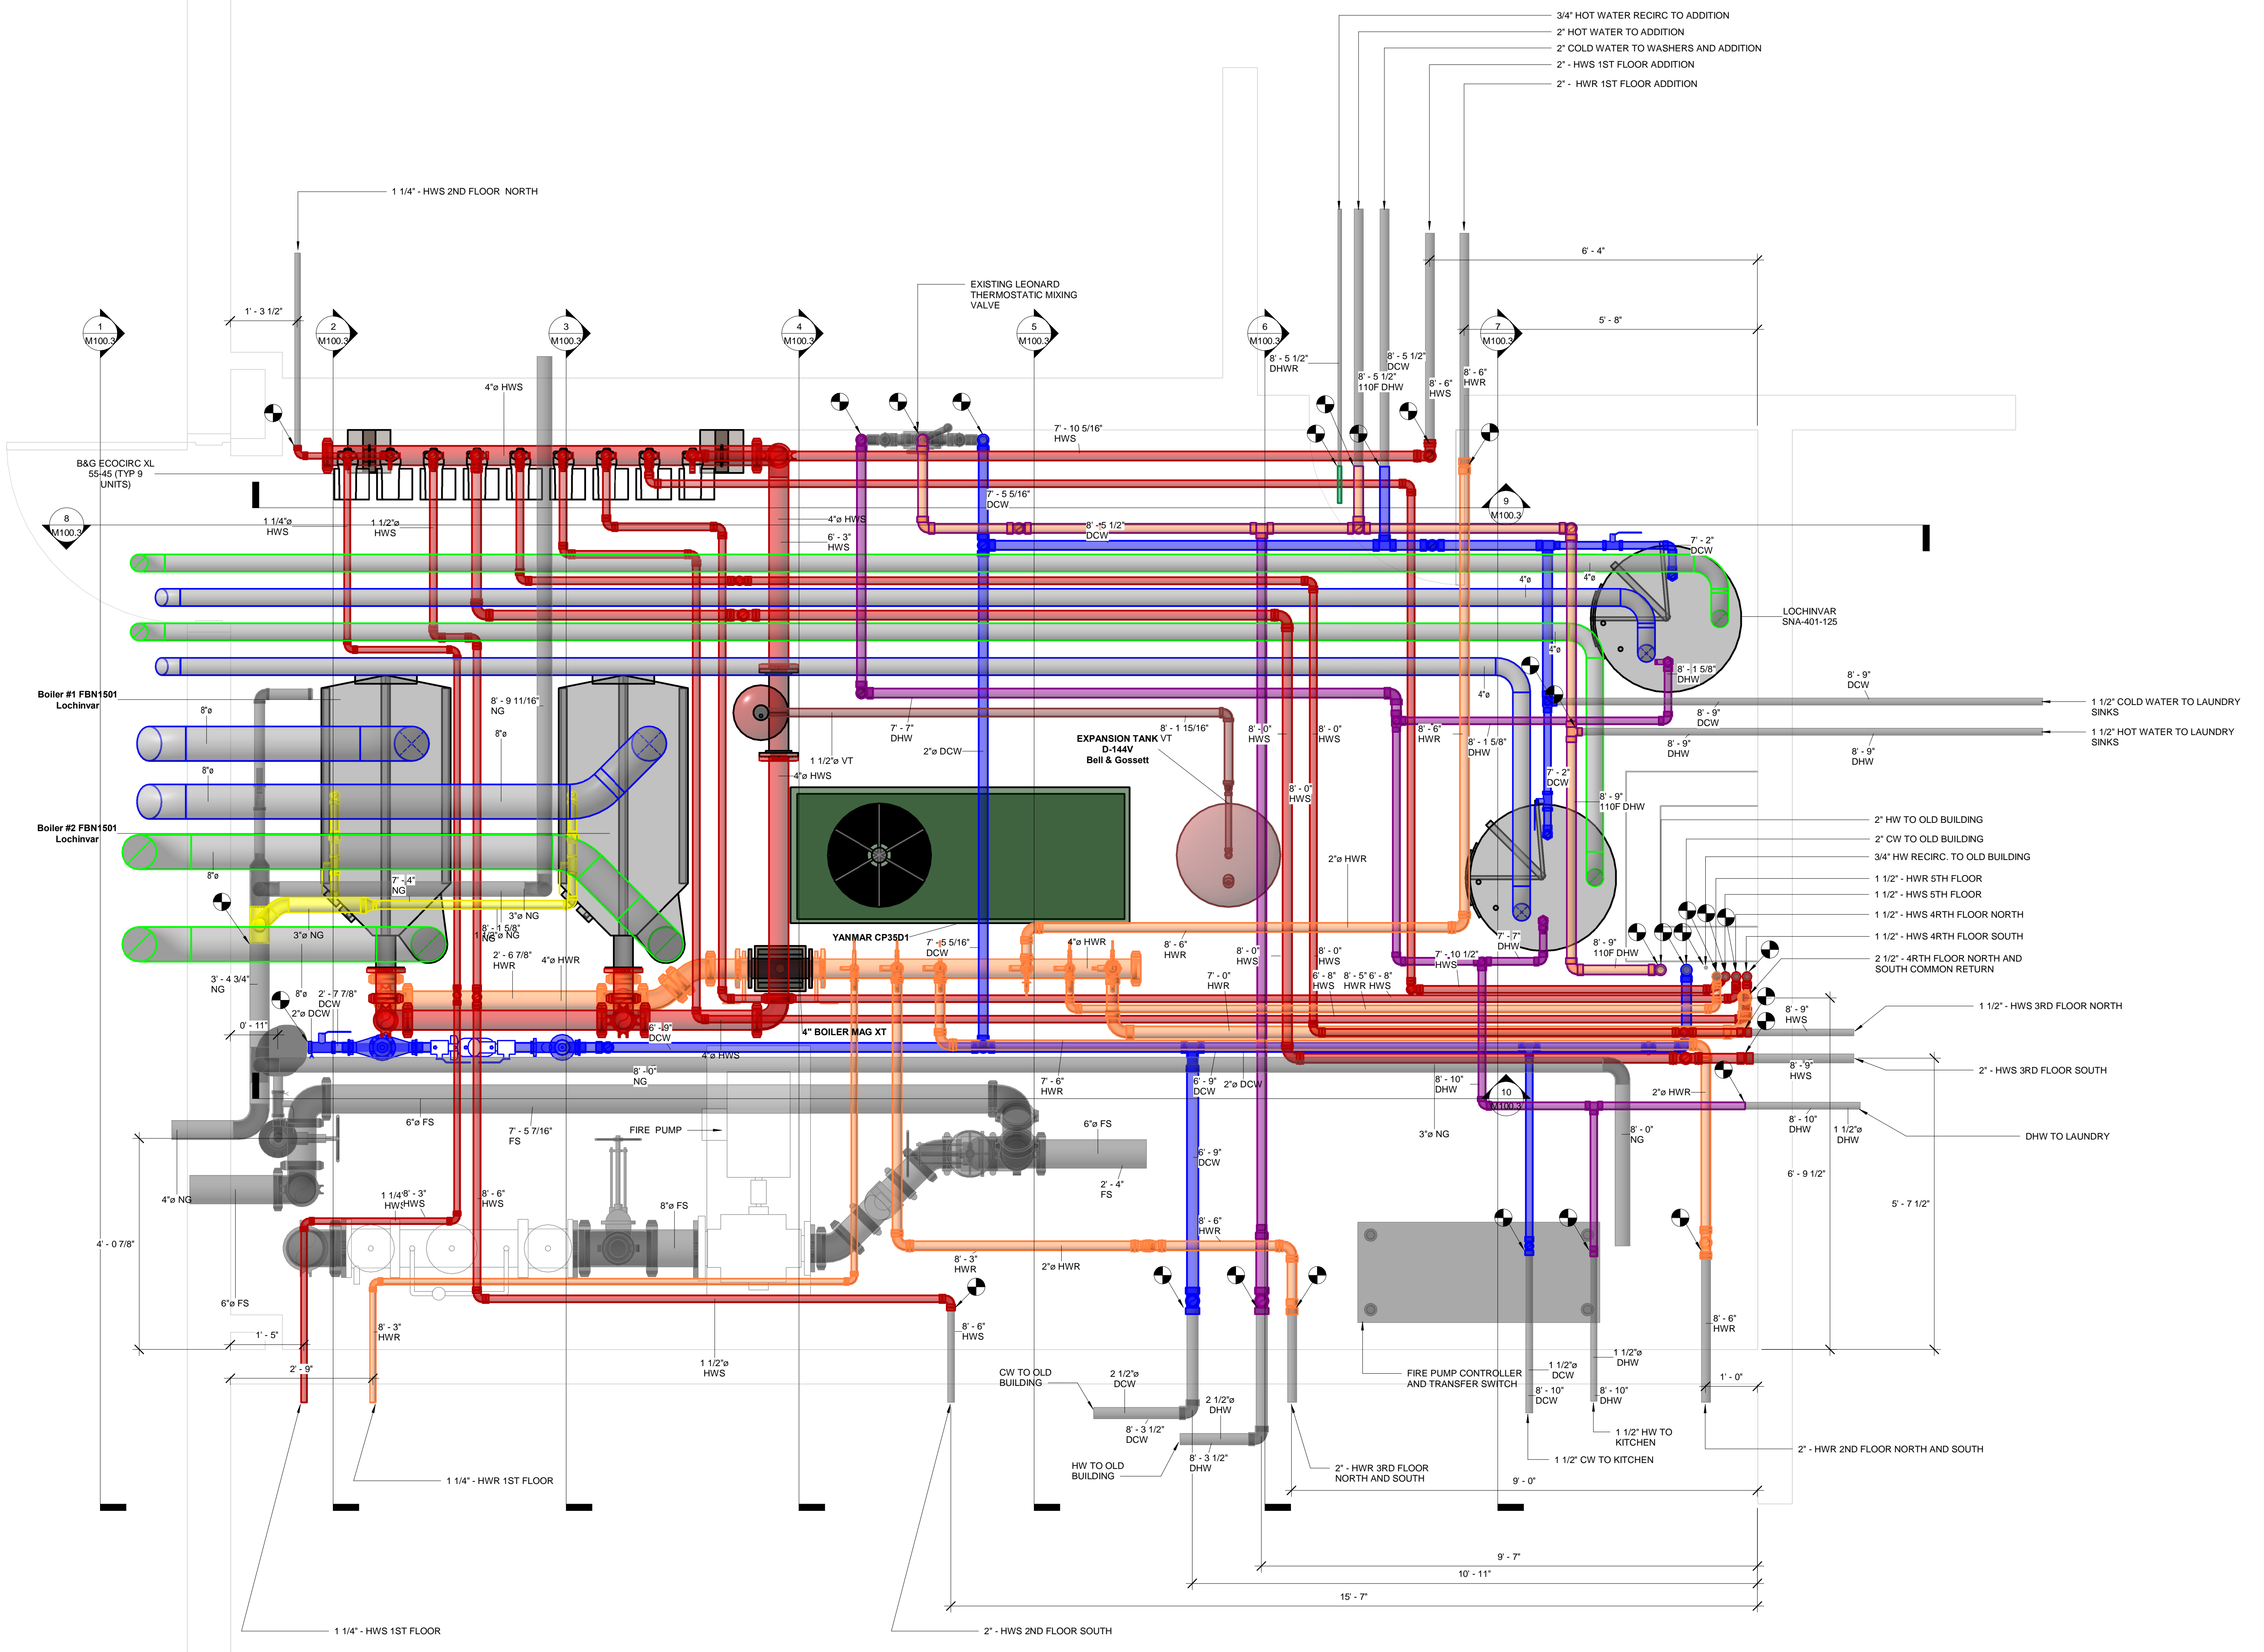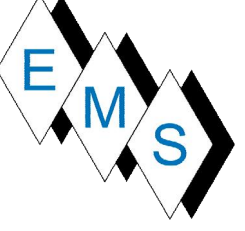

No.	Description	Date

BRIDGEPORT RESCUE MISSION, INC.

JOEL SMILOW CARE CENTER


725 PARK AVENUE
BRIDGEPORT, CT

BOILER ROOM PLAN

Project Number	4929
Date	9/23/19
Drawn By	T.H.
Checked By	P.M.

M100.2

Scale	3/4" = 1'-0"
-------	--------------

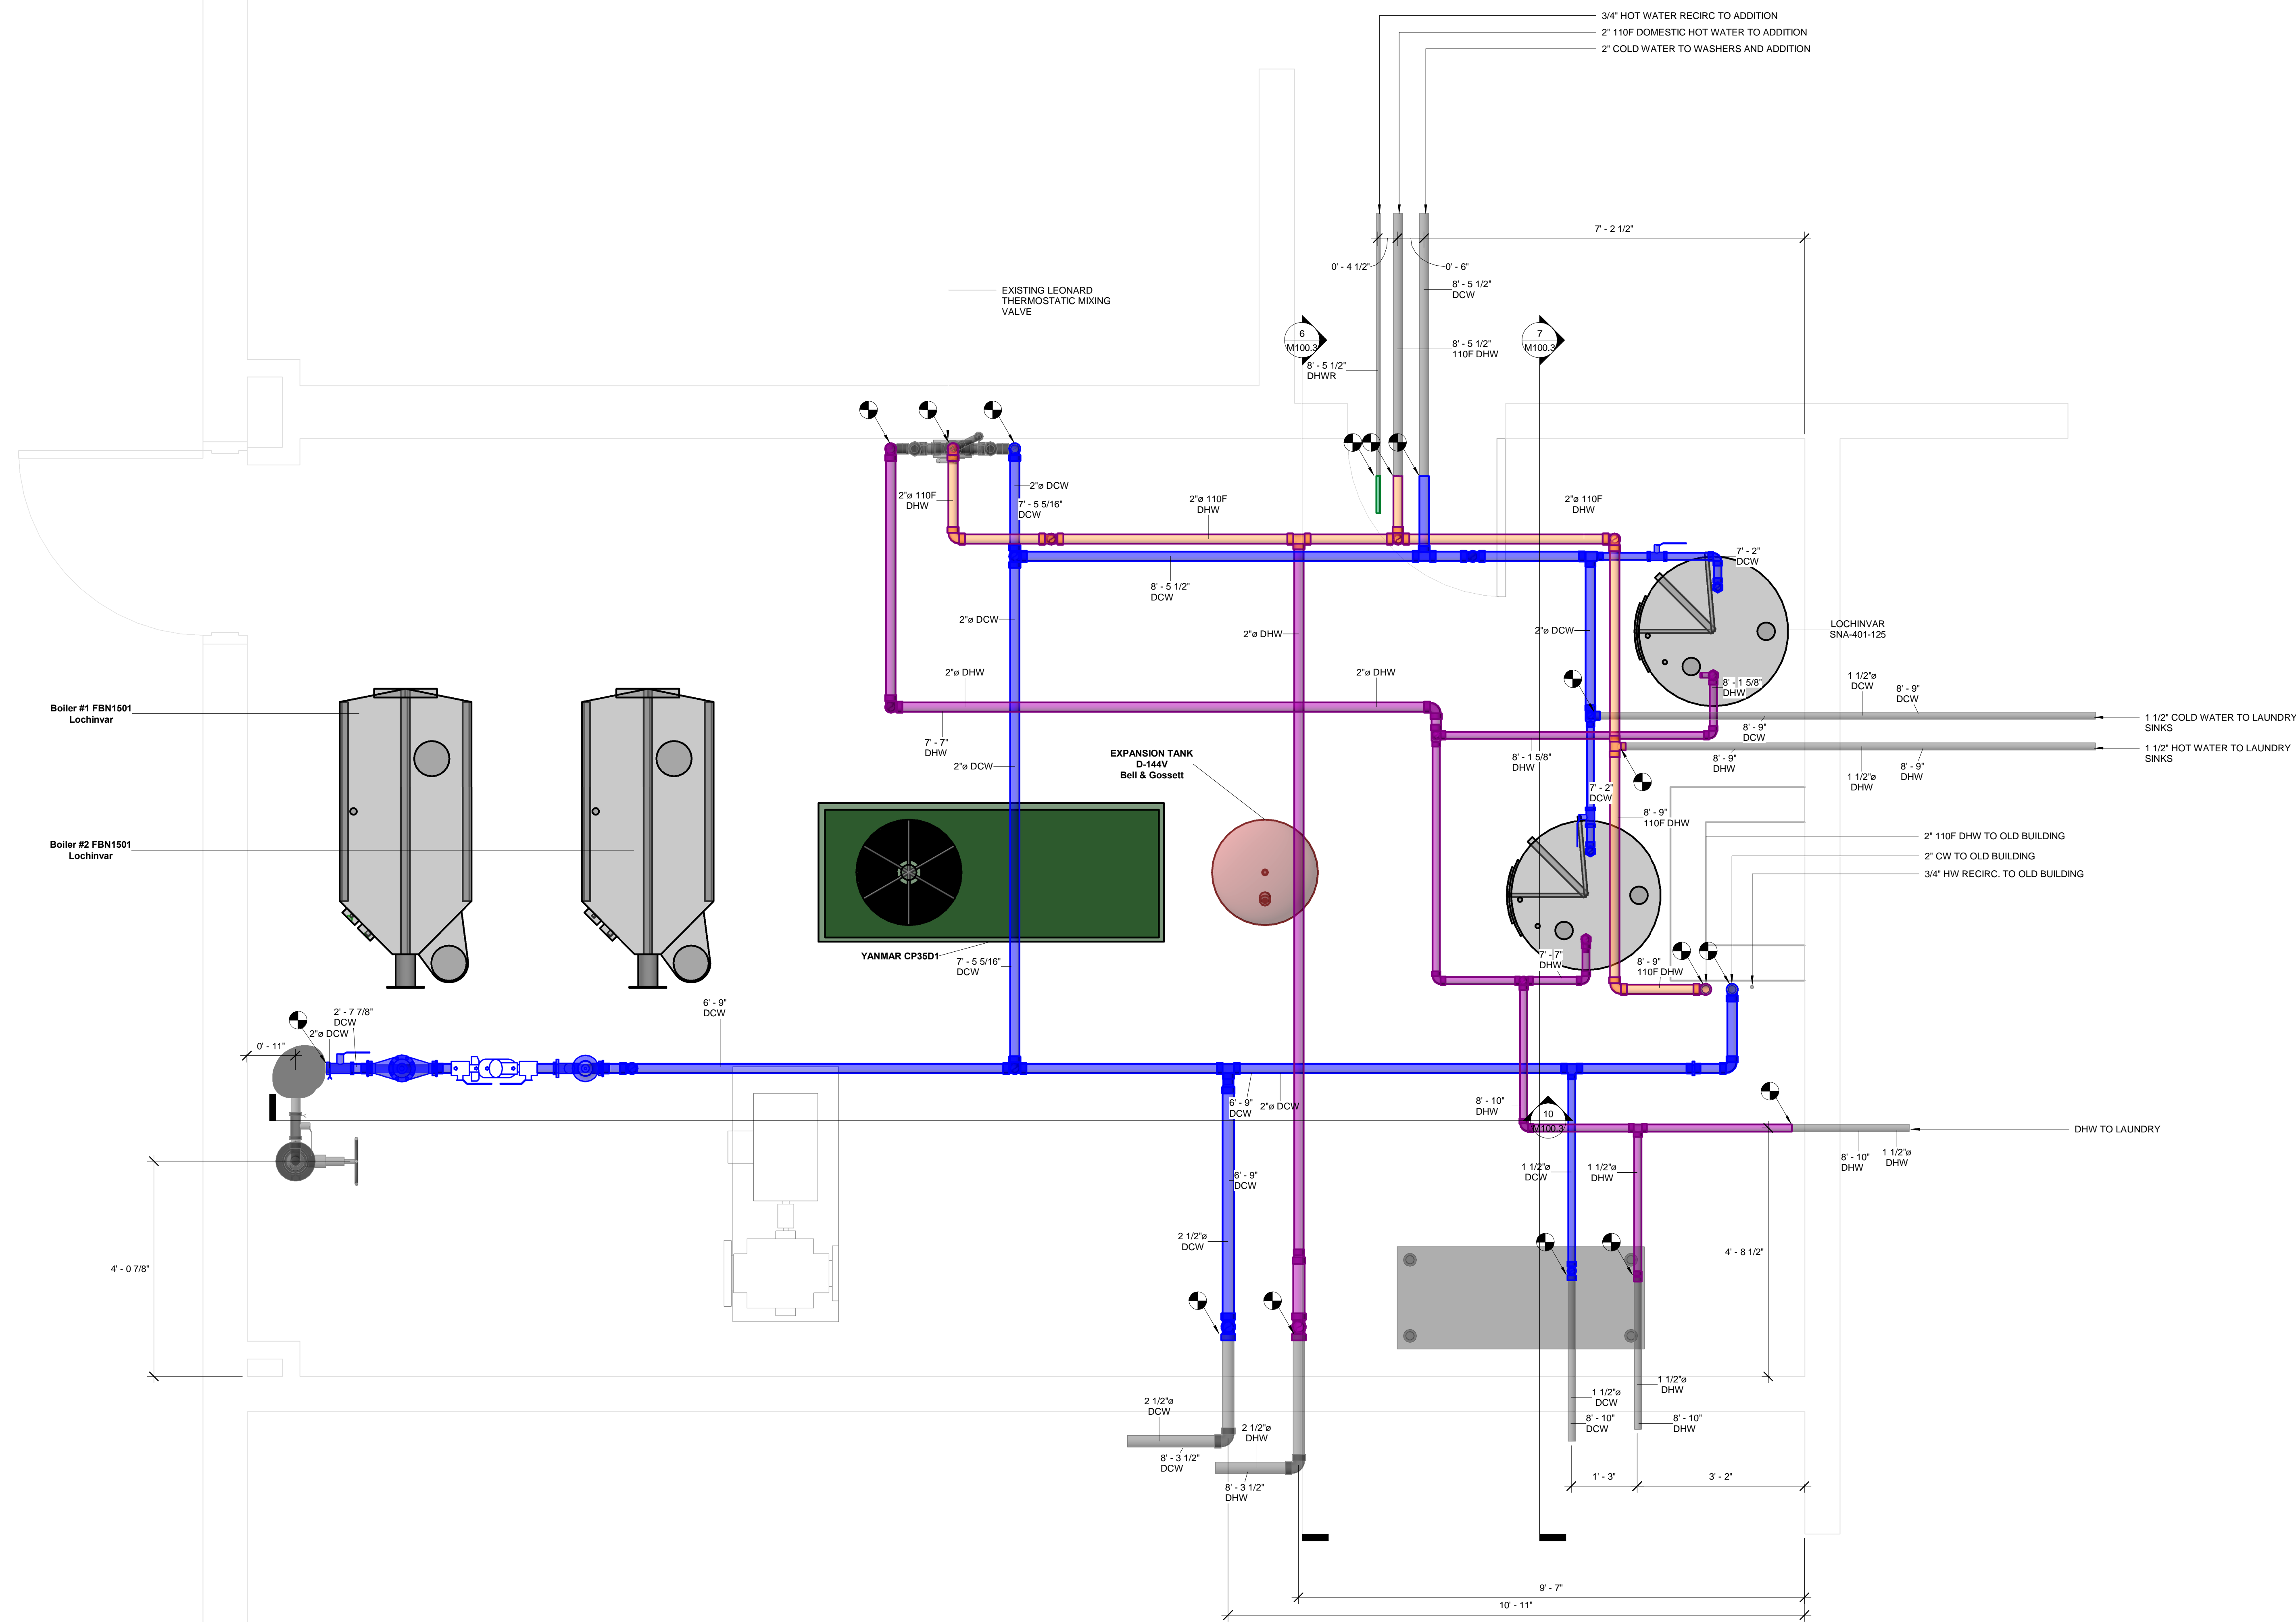

No.	Description	Date

BRIDGEPORT RESCUE MISSION, INC.
JOEL SMILOW CARE CENTER
725 PARK AVENUE
BRIDGEPORT, CT


BOILER ROOM PLUMBING PLAN

Project Number	4929
Date	9/23/19
Drawn By	T.H.
Checked By	P.M.

M100.4


Scale	3/4" = 1'-0"
-------	--------------

1 NEW BOILER ROOM PLUMBING PLAN
3/4" = 1'-0"

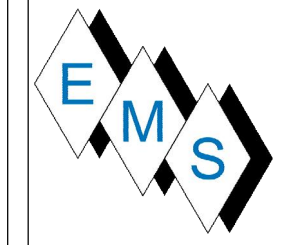

Eastern Mechanical Services, Inc.
3 Starr Street
Danbury, CT 06810
203.792.7668

www.emsinc.us

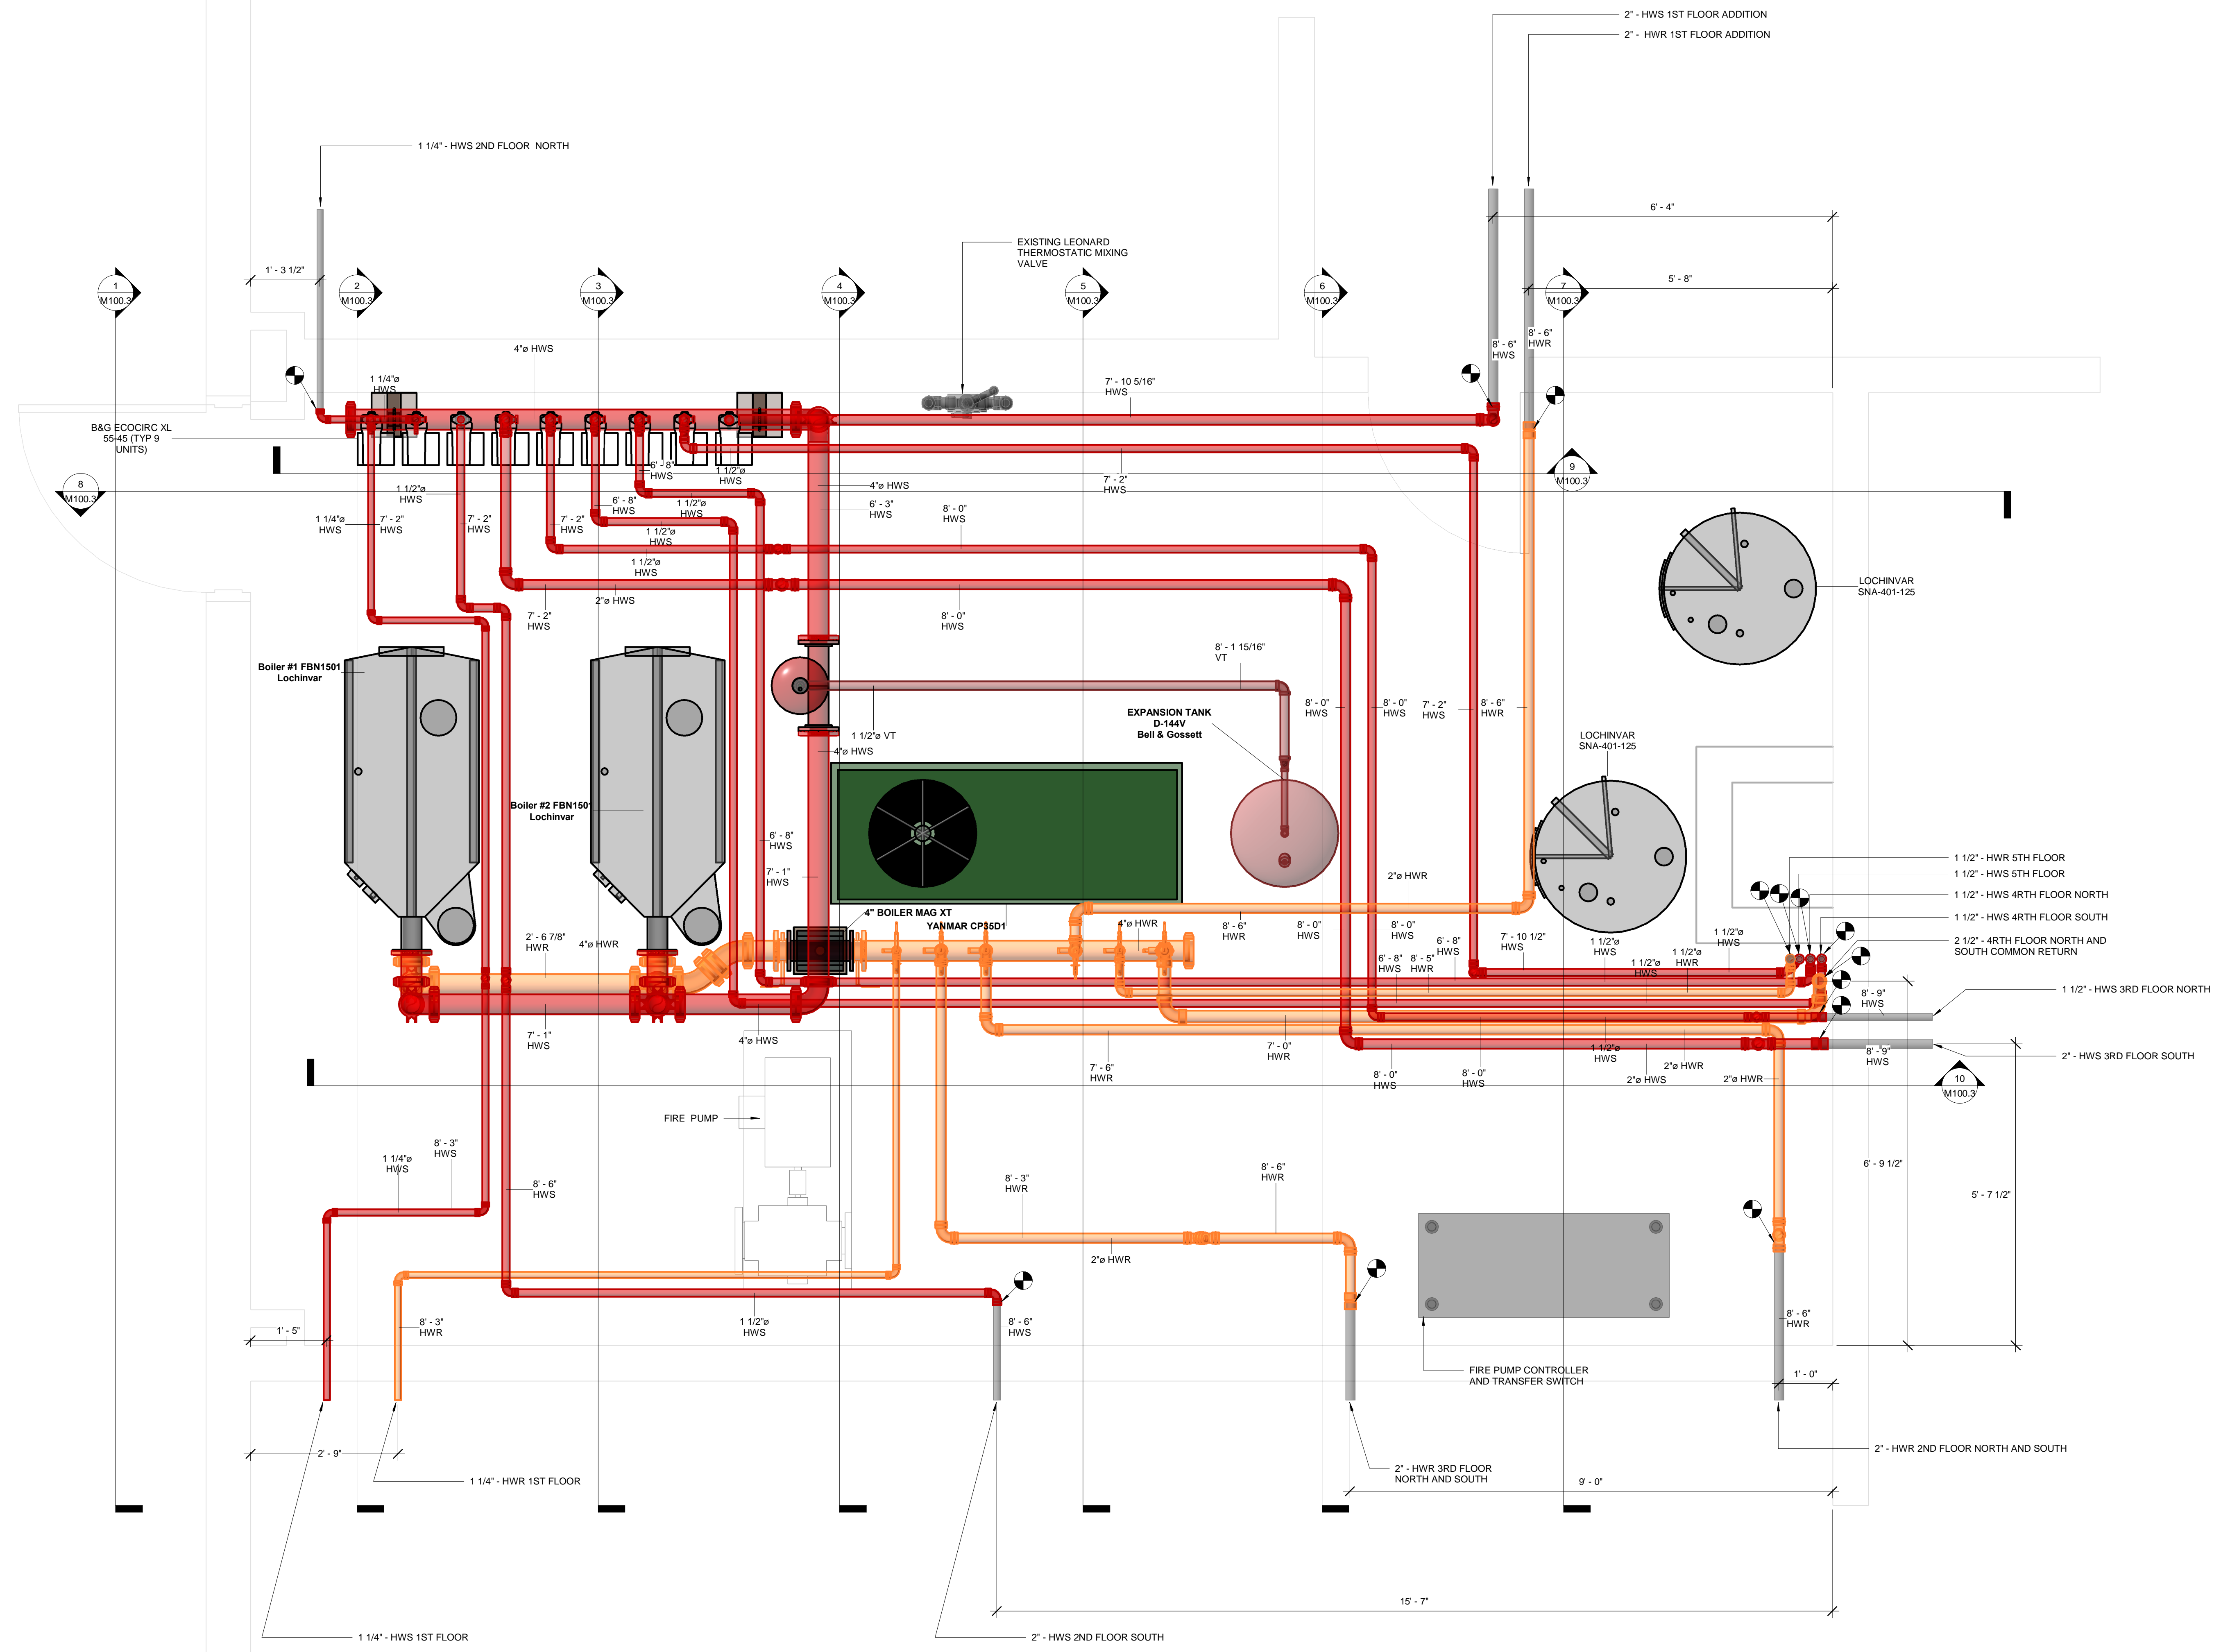

No.	Description	Date

BRIDGEPORT RESCUE MISSION, INC.

JOEL SMILOW CARE CENTER

**725 PARK AVENUE
BRIDGEPORT, CT**

BOILER ROOM HWS HWR PLAN


Project Number	4929
Date	9/23/19
Drawn By	T.H.
Checked By	P.M.

M100.5

Scale 3/4" = 1'-0"


NEW BOILER ROOM HWS HWR PLAN
3/4" = 1'-0"

10/1/2019 9:56:43 AM

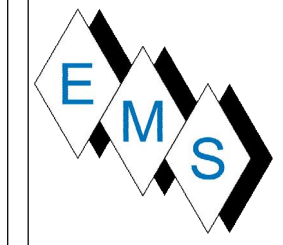

Eastern Mechanical Services, Inc.
 3 Starr Street
 Danbury, CT 06810
 203.792.7668

www.emsinc.us

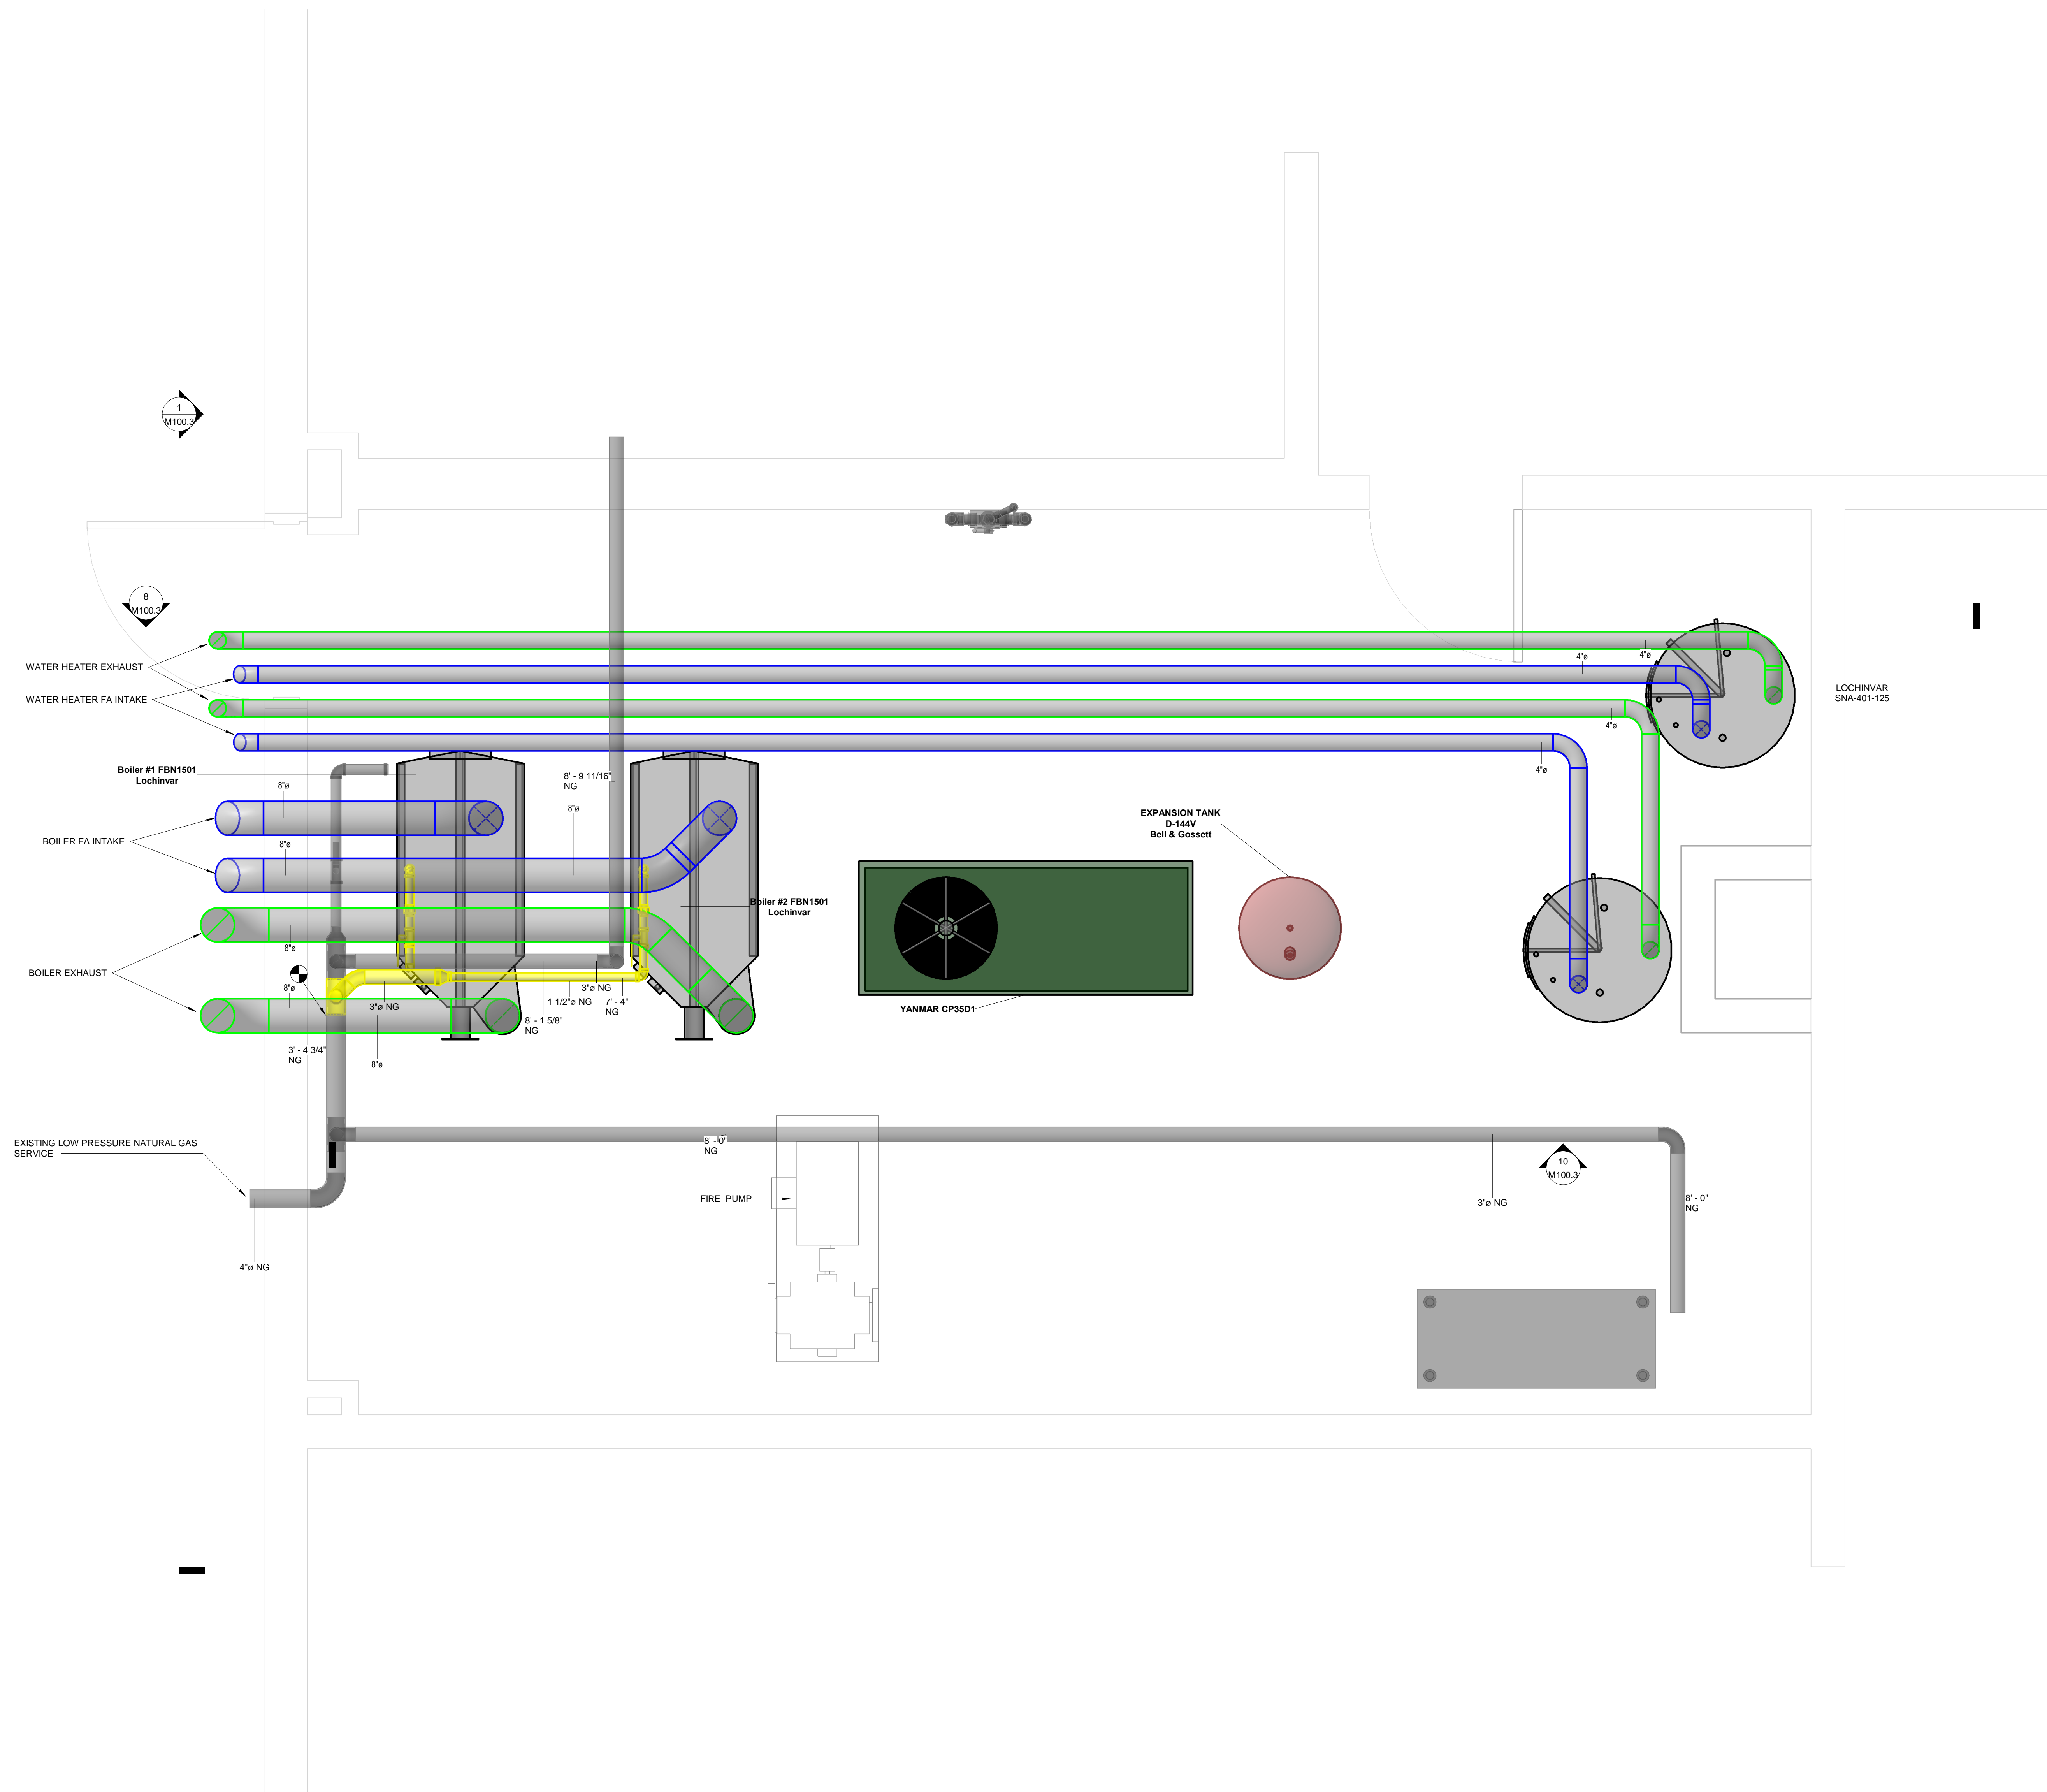

No.	Description	Date

BRIDGEPORT RESCUE MISSION,
 INC.

JOEL SMILOW CARE CENTER

725 PARK AVENUE
 BRIDGEPORT, CT

BOILER ROOM GAS AND VENTING PLAN



Project Number	4929
Date	9/23/19
Drawn By	T.H.
Checked By	P.M.

M100.6

Scale 3/4" = 1'-0"

NEW BOILER ROOM GAS AND VENT
 ①-PLAN
 3/4" = 1'-0"

10/1/2019 10:10:59 AM

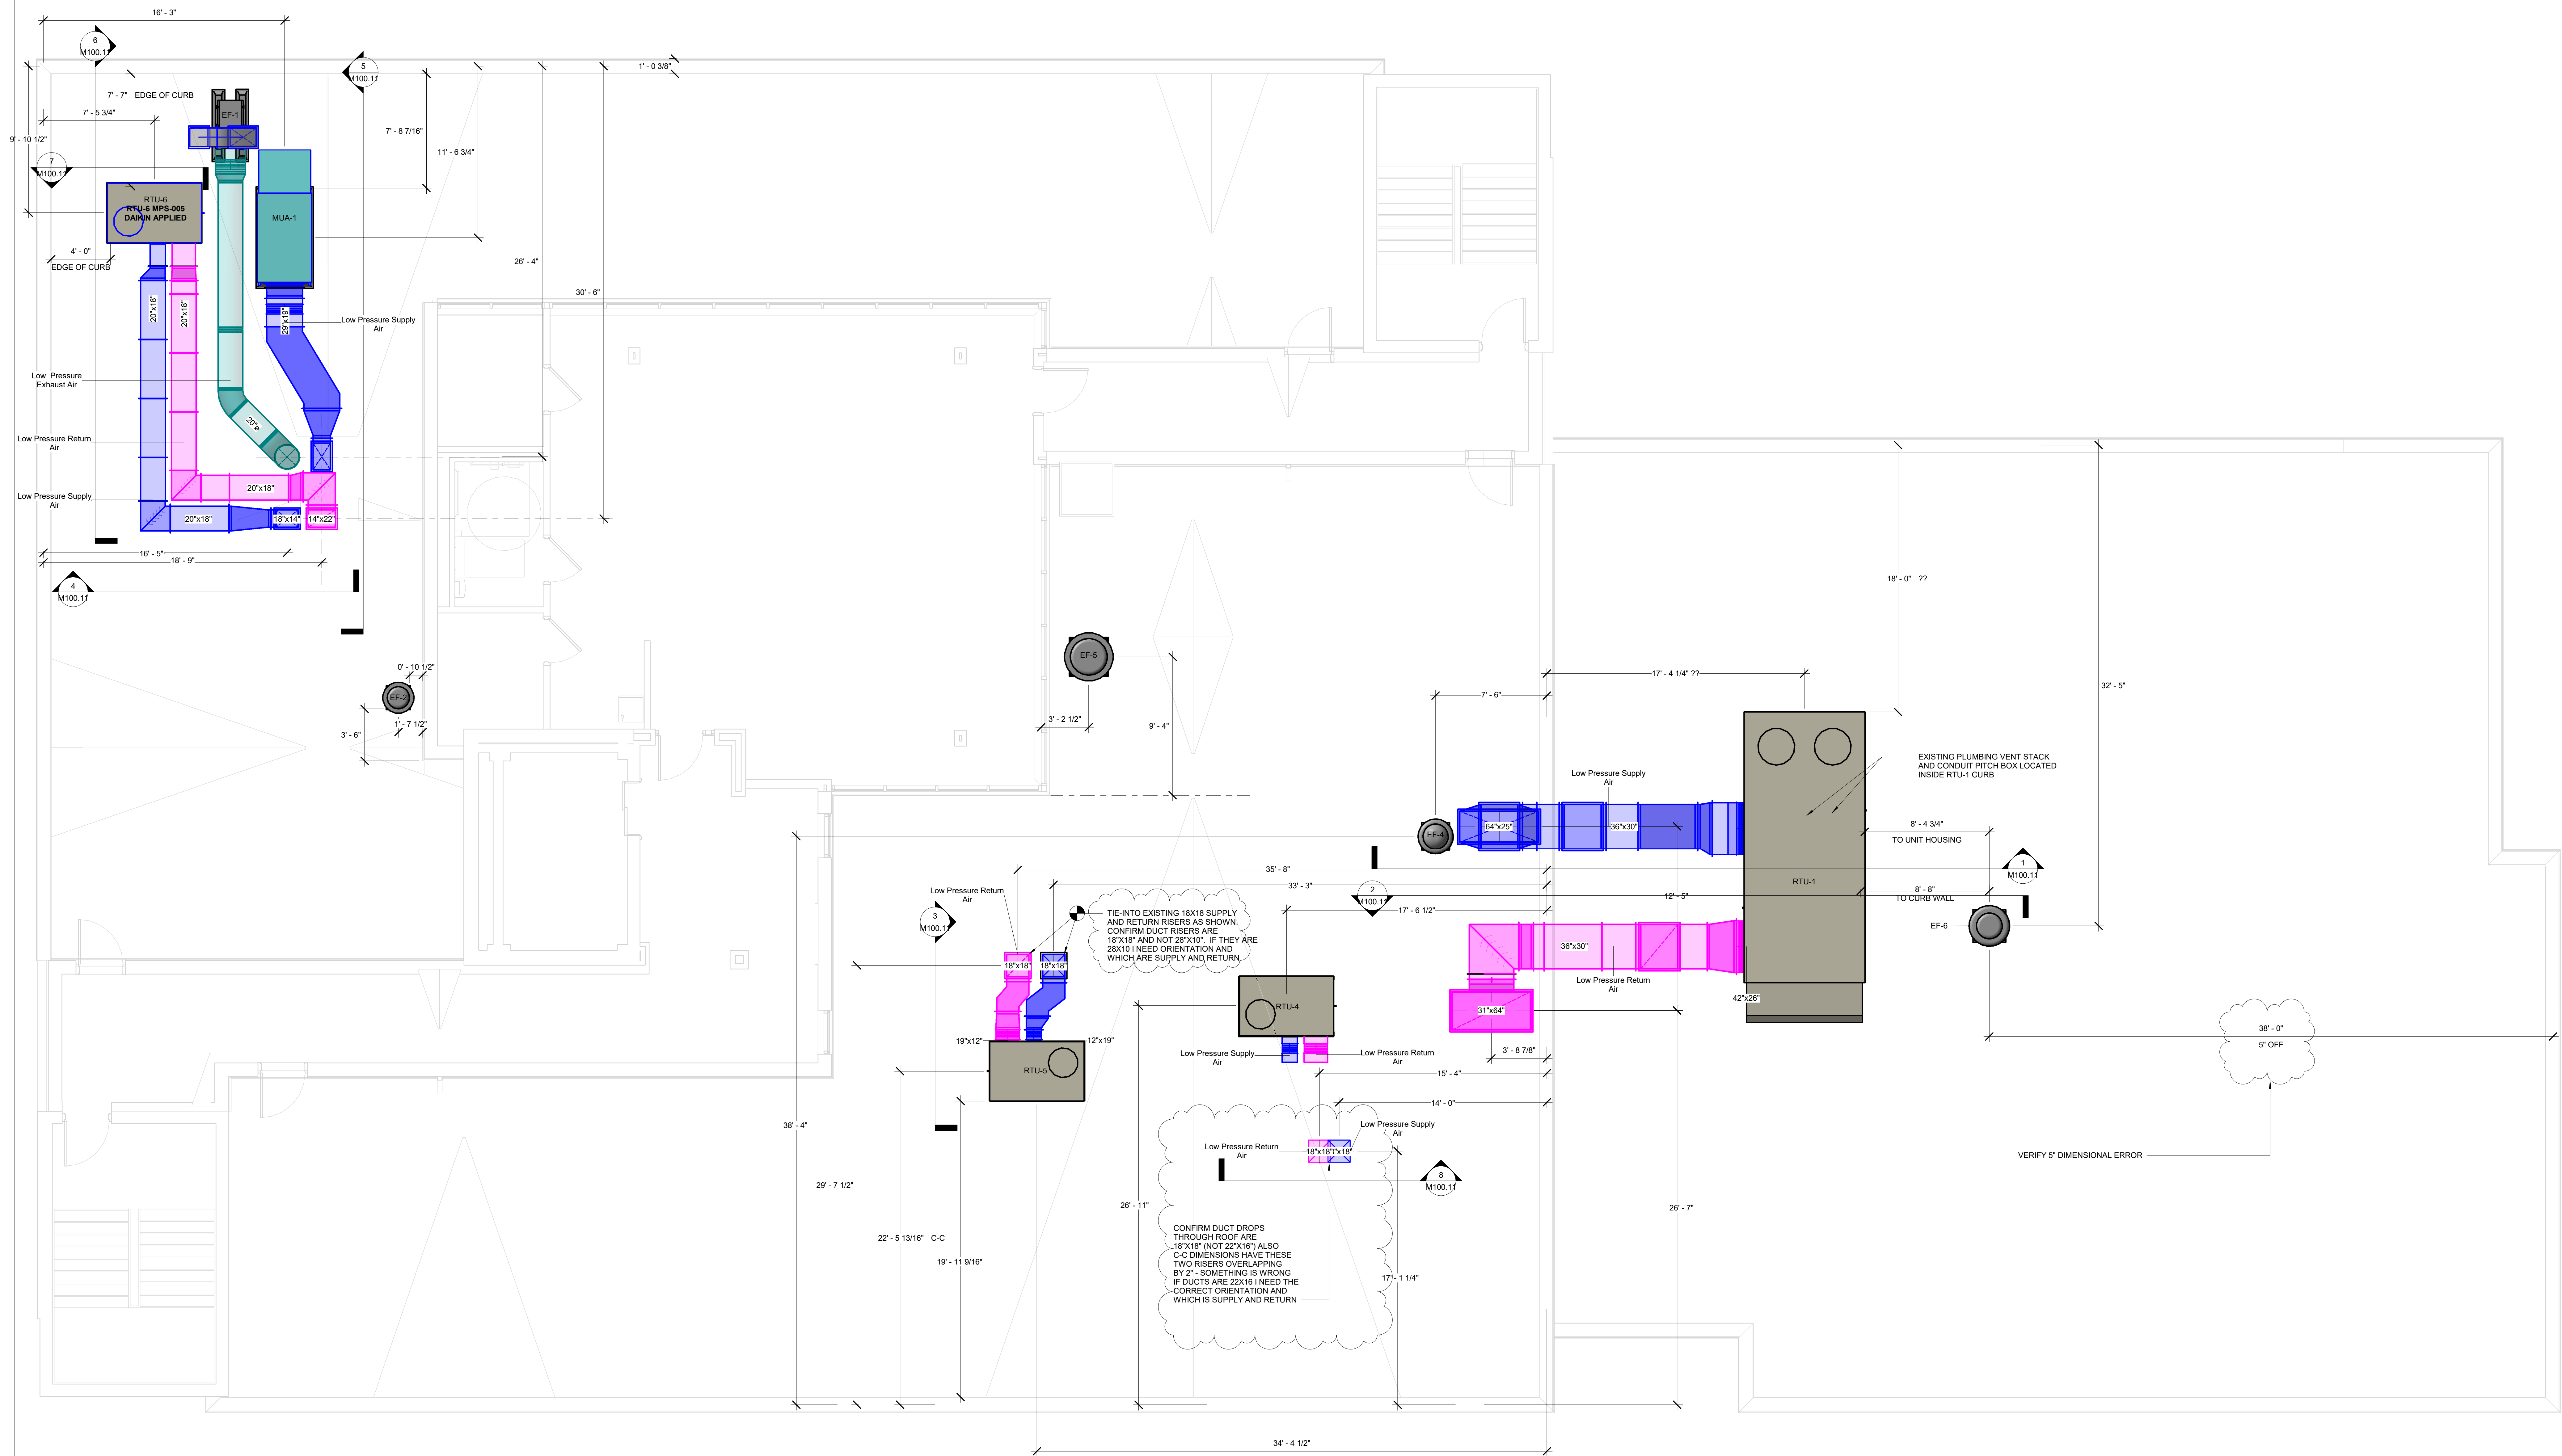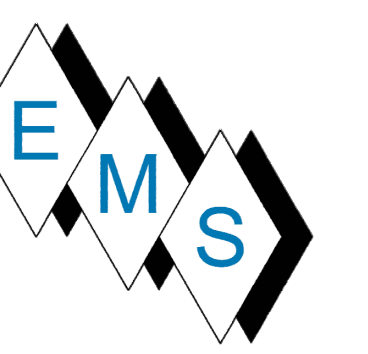

No.	Description	Date
1	Revision 1	Date 1

BRIDGEPORT RESCUE MISSION, INC.
 JOEL SMILOW CARE CENTER
 725 PARK AVENUE
 BRIDGEPORT, CT 06604


Roof Plan

Project Number	4929
Date	1/31/2020
Drawn By	T.H.
Checked By	J.M.


M100.10

1 FIFTH FLOOR
 1/4" = 1'-0"


2/18/2020 8:50:27 PM

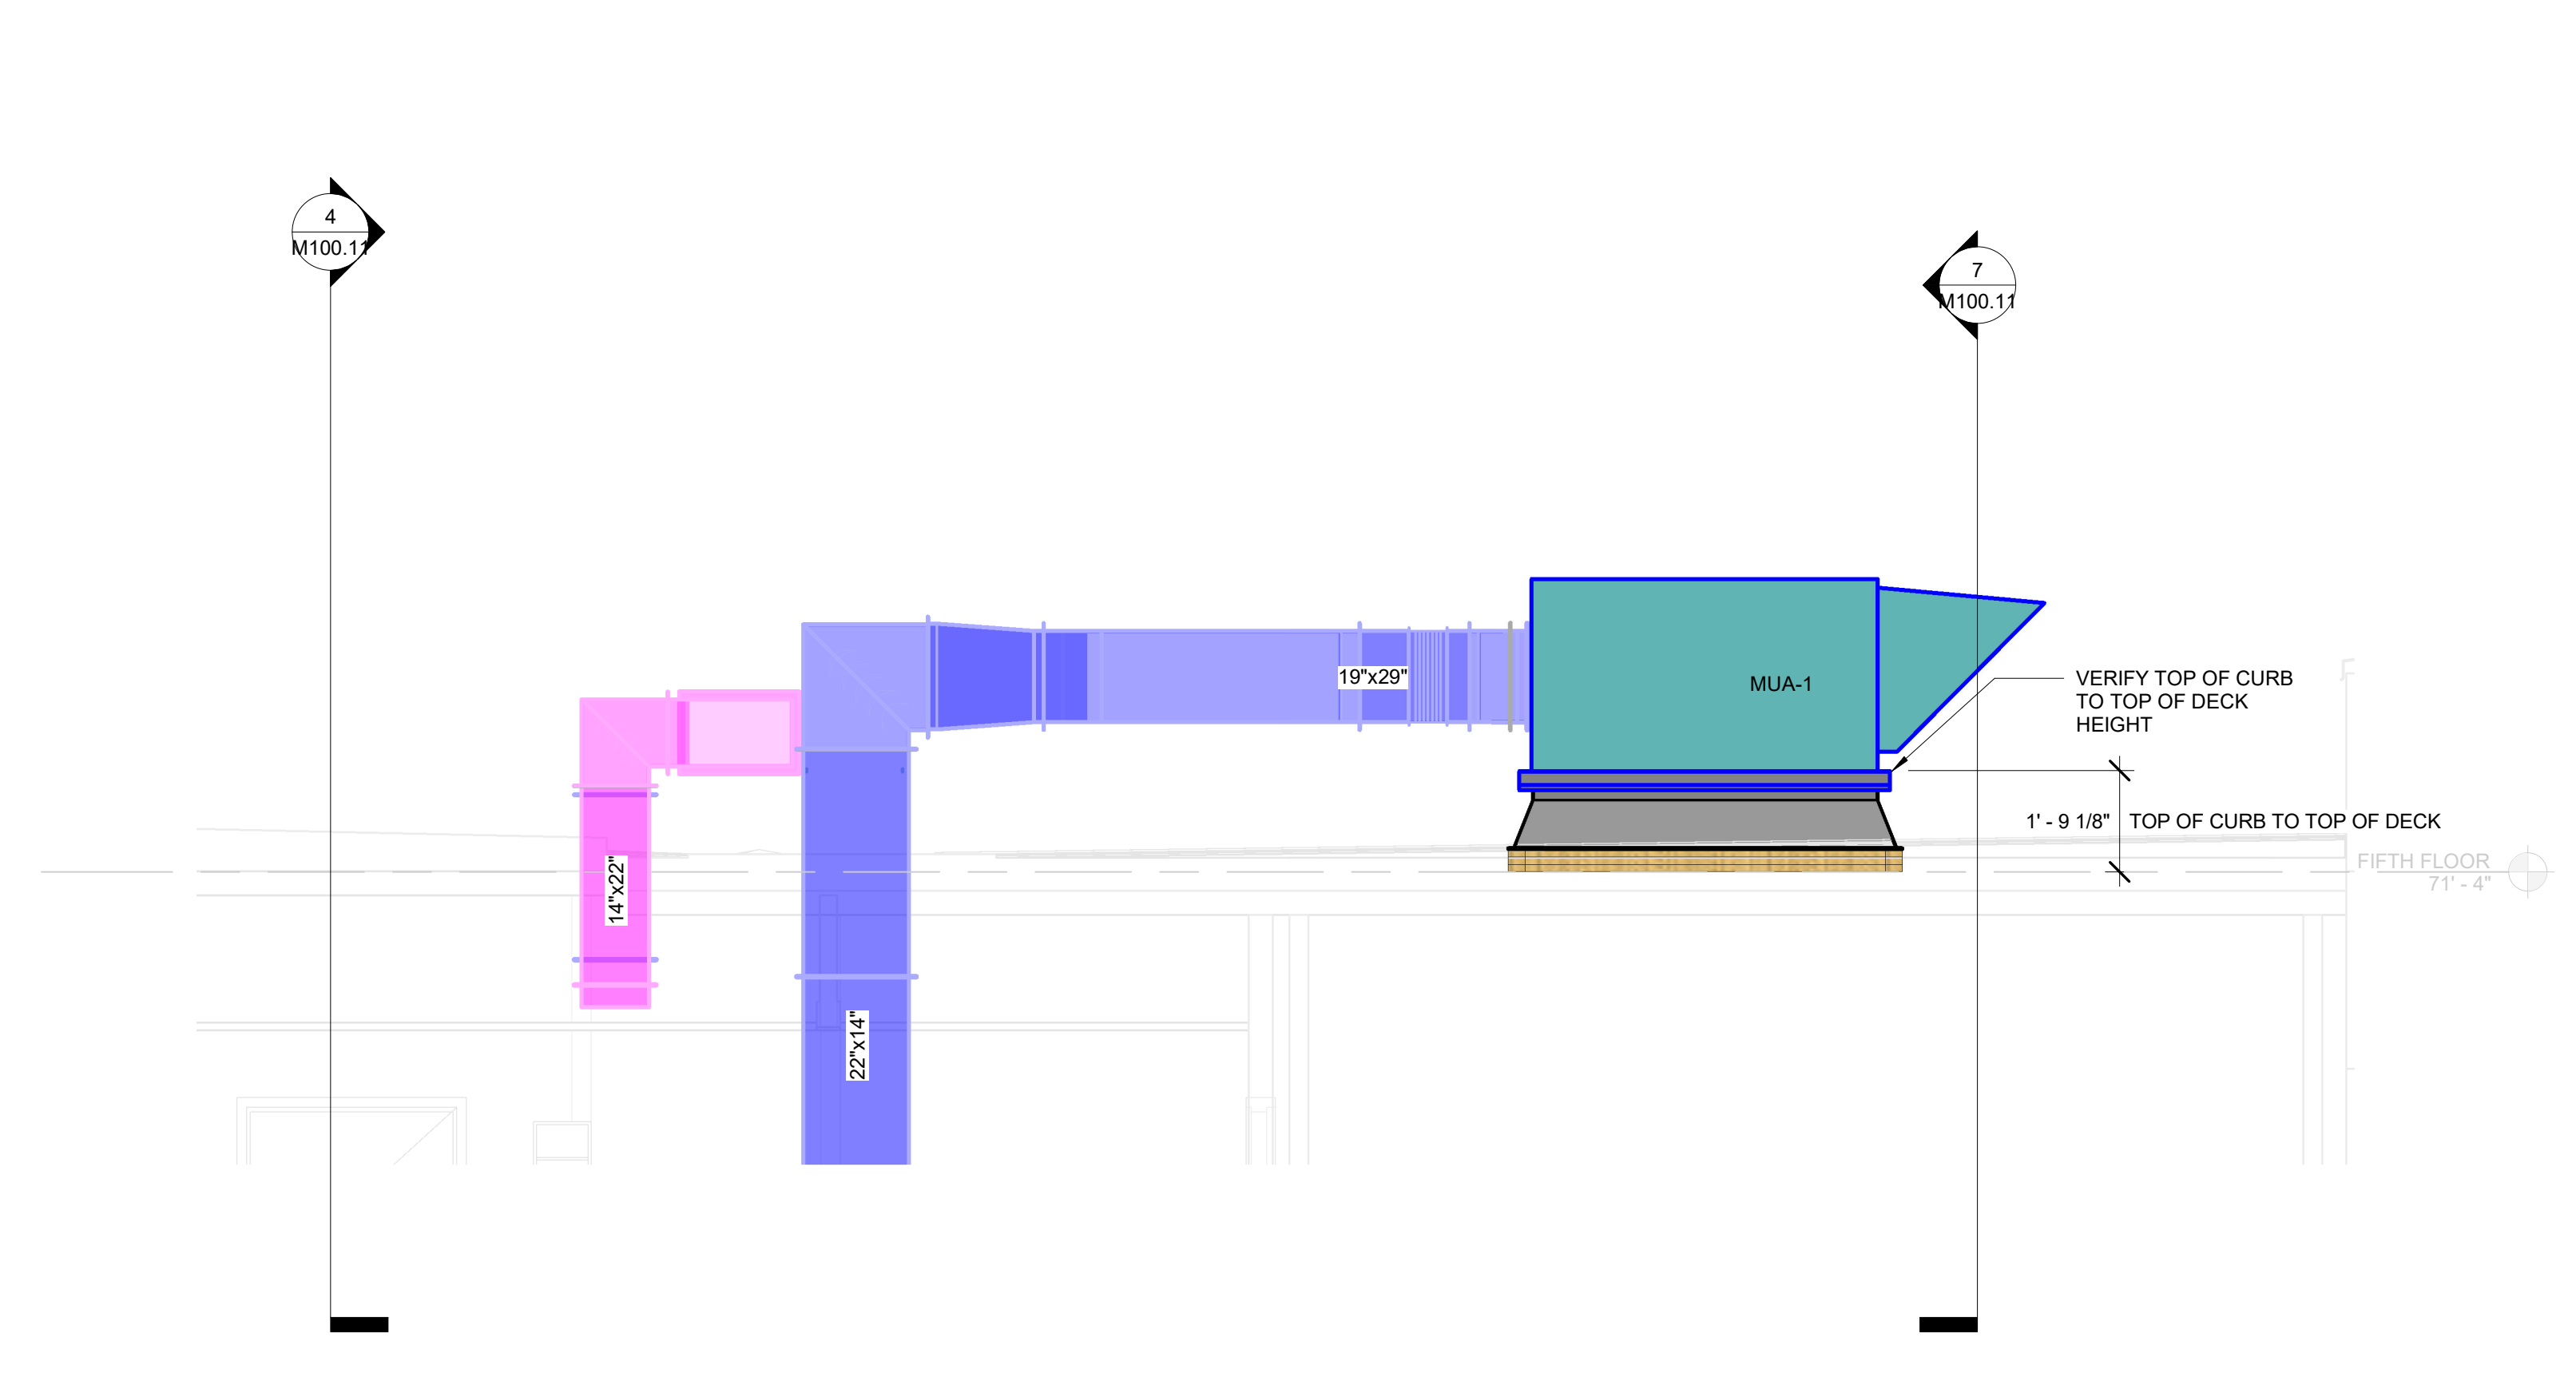


5 Section 12
3/8" = 1'-0"

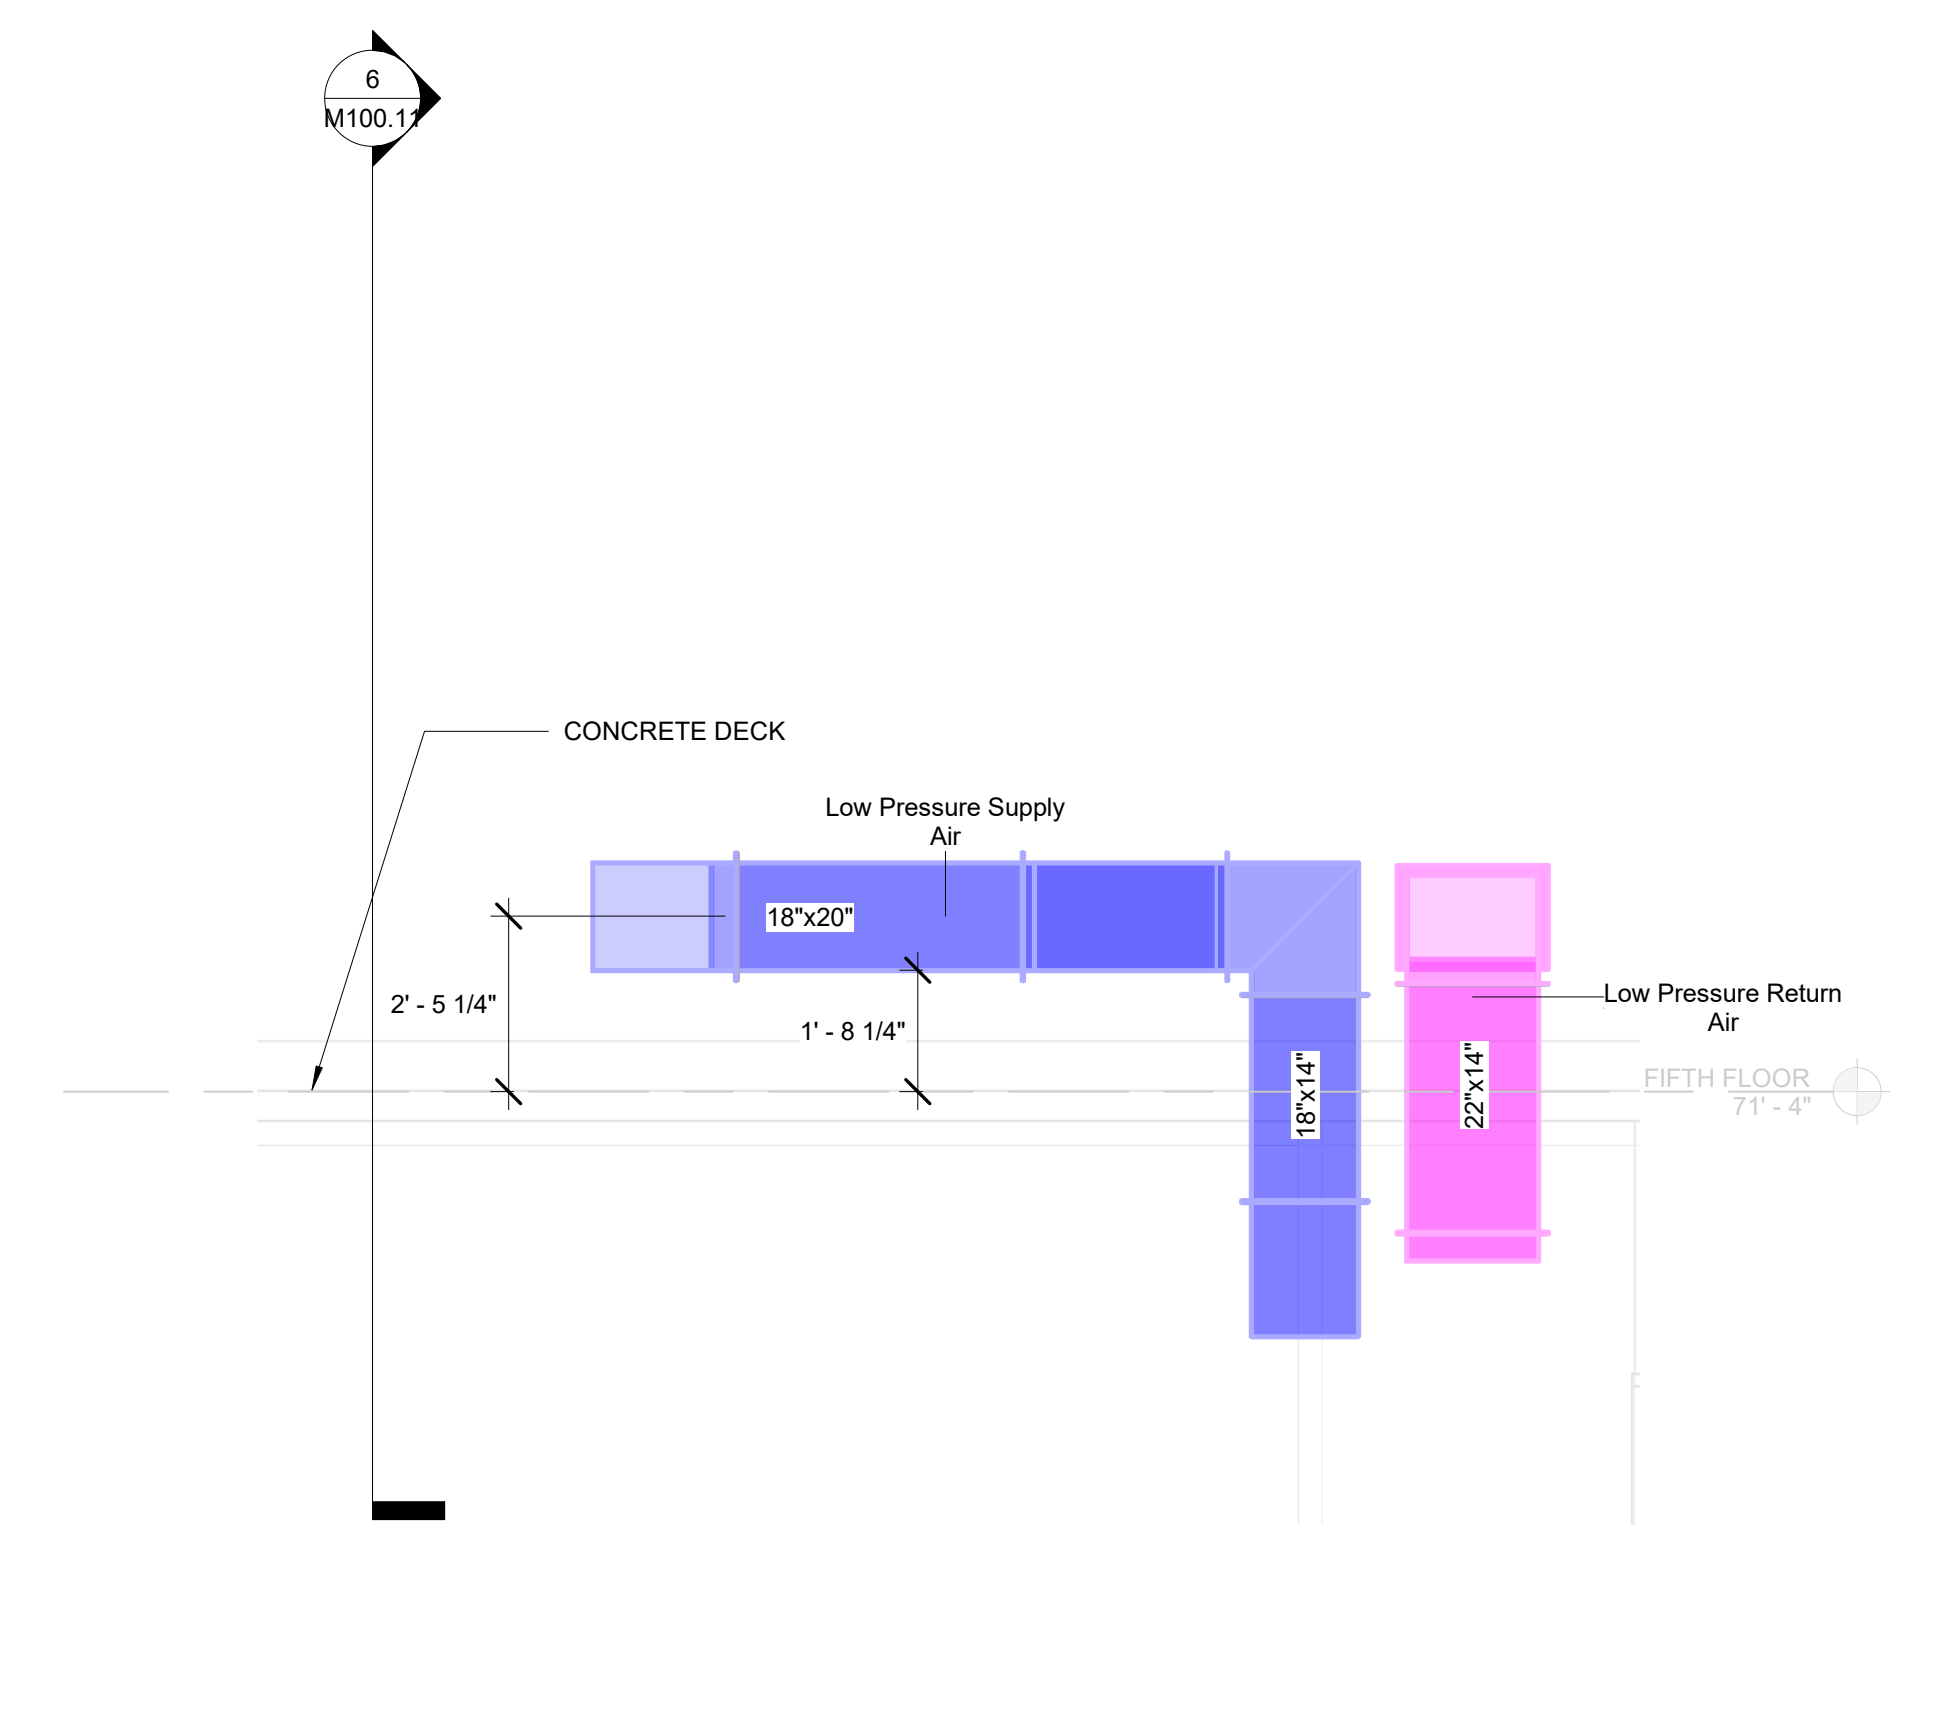


4 Section 13
3/8" = 1'-0"

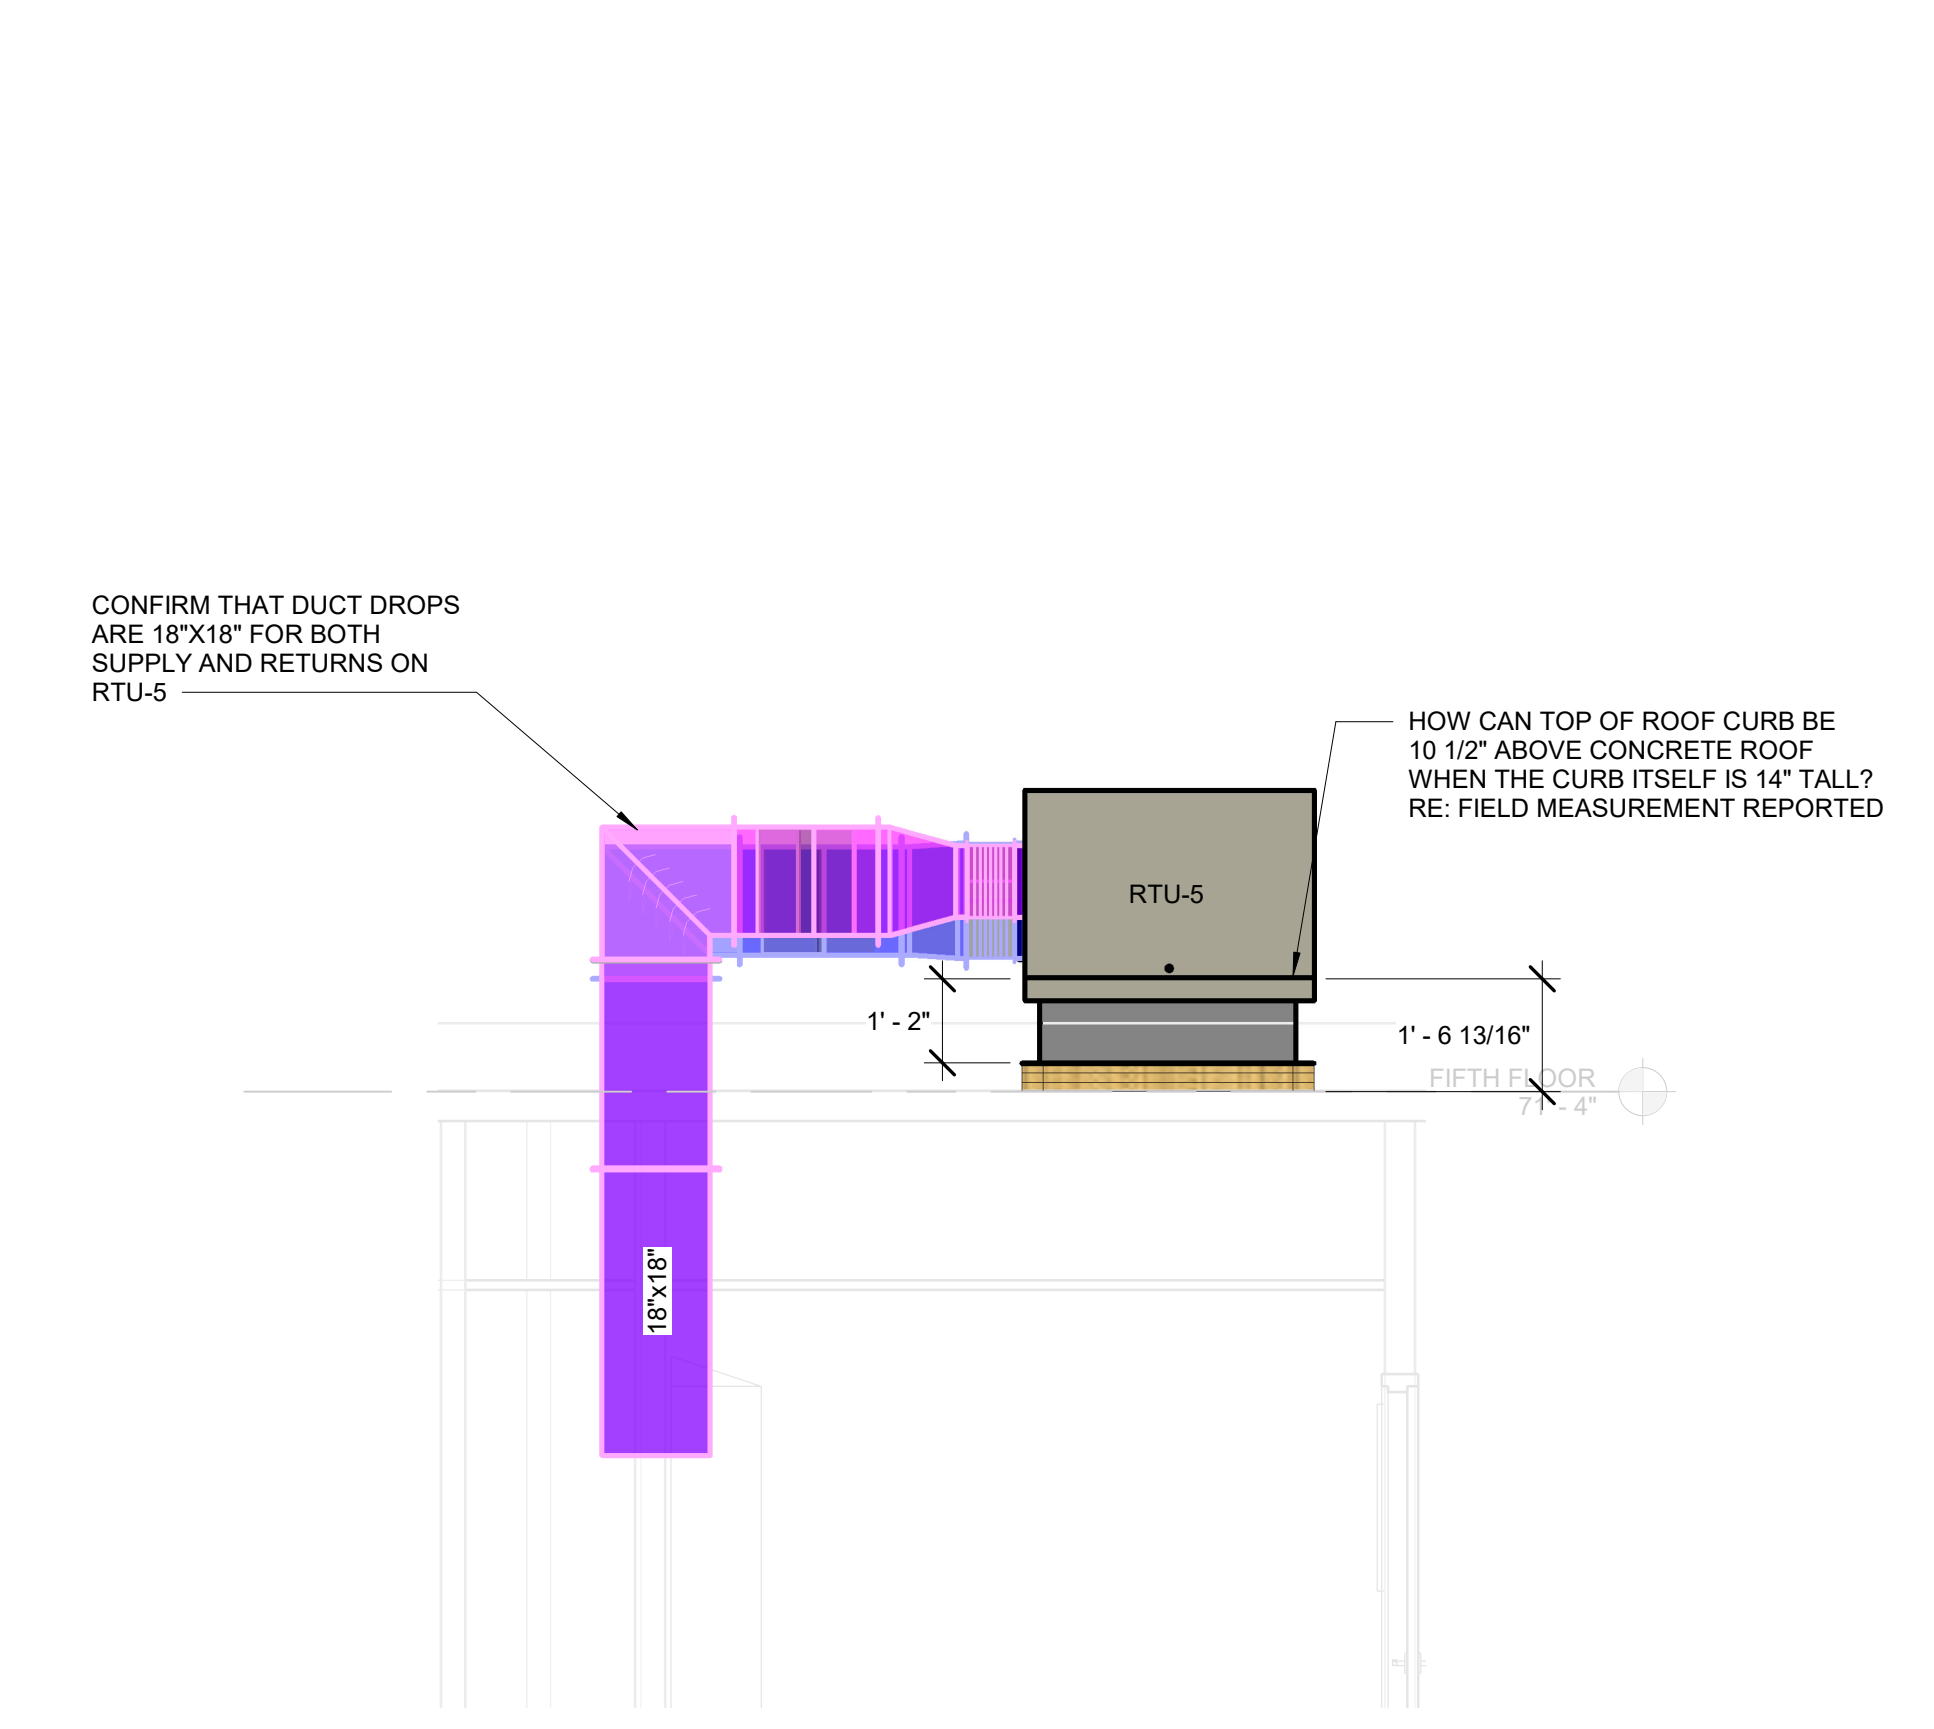


3 Section 14
3/8" = 1'-0"

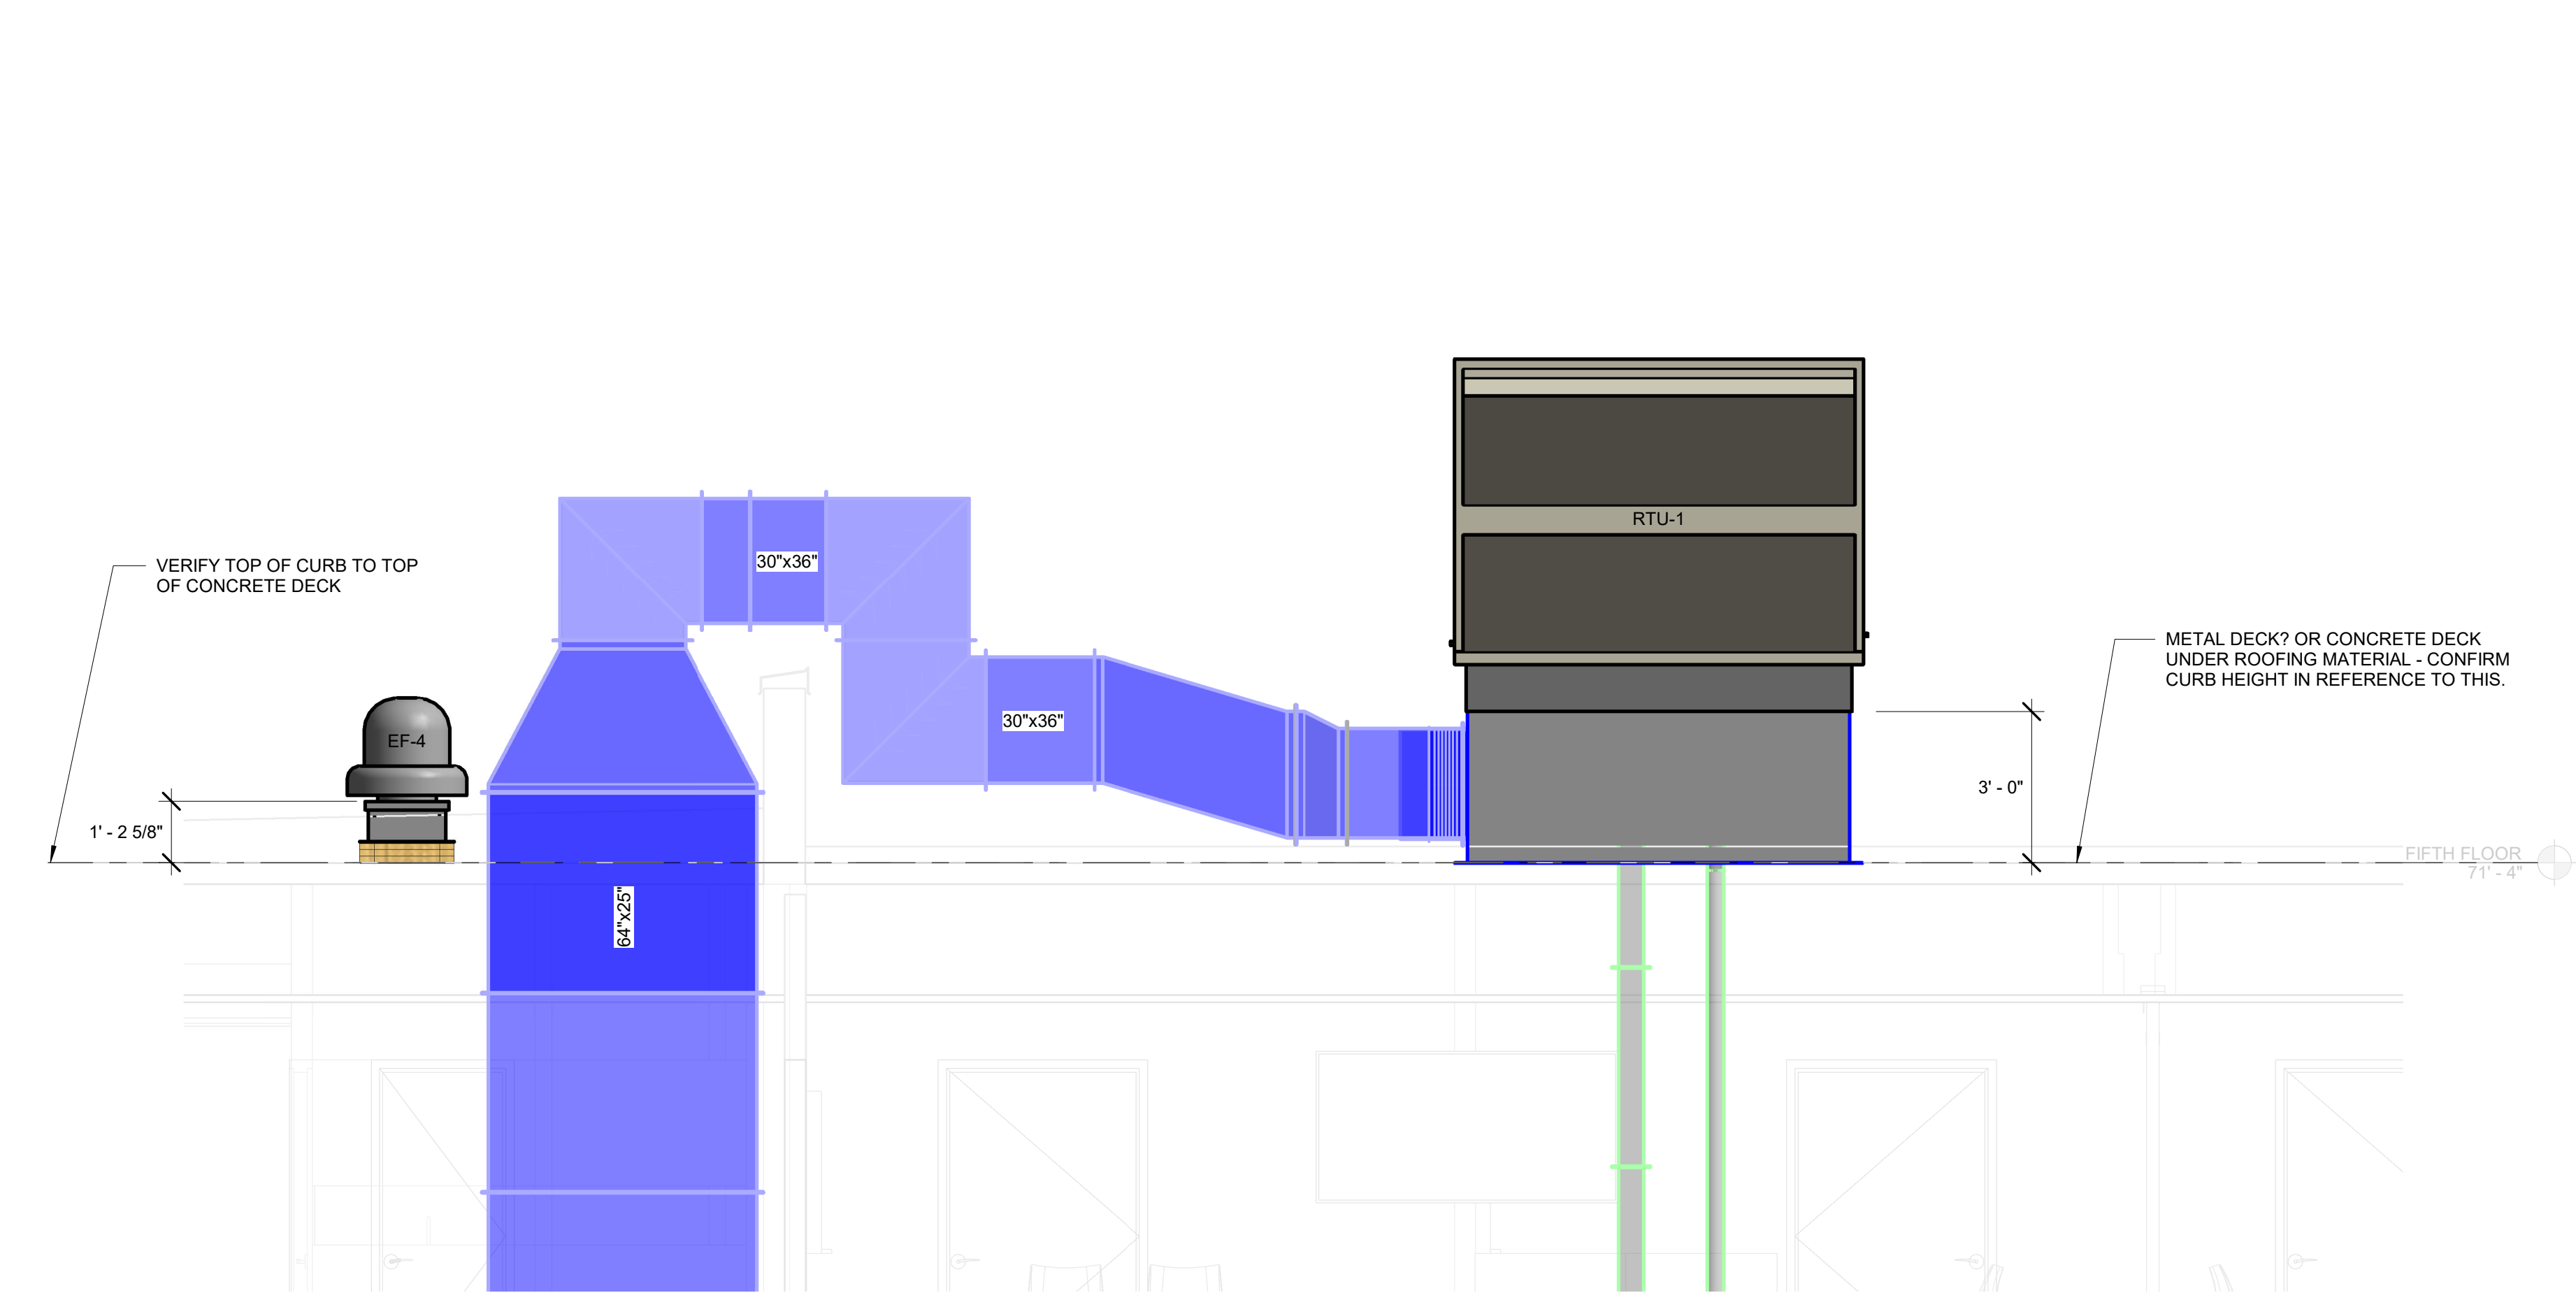


1 Section 15
3/8" = 1'-0"

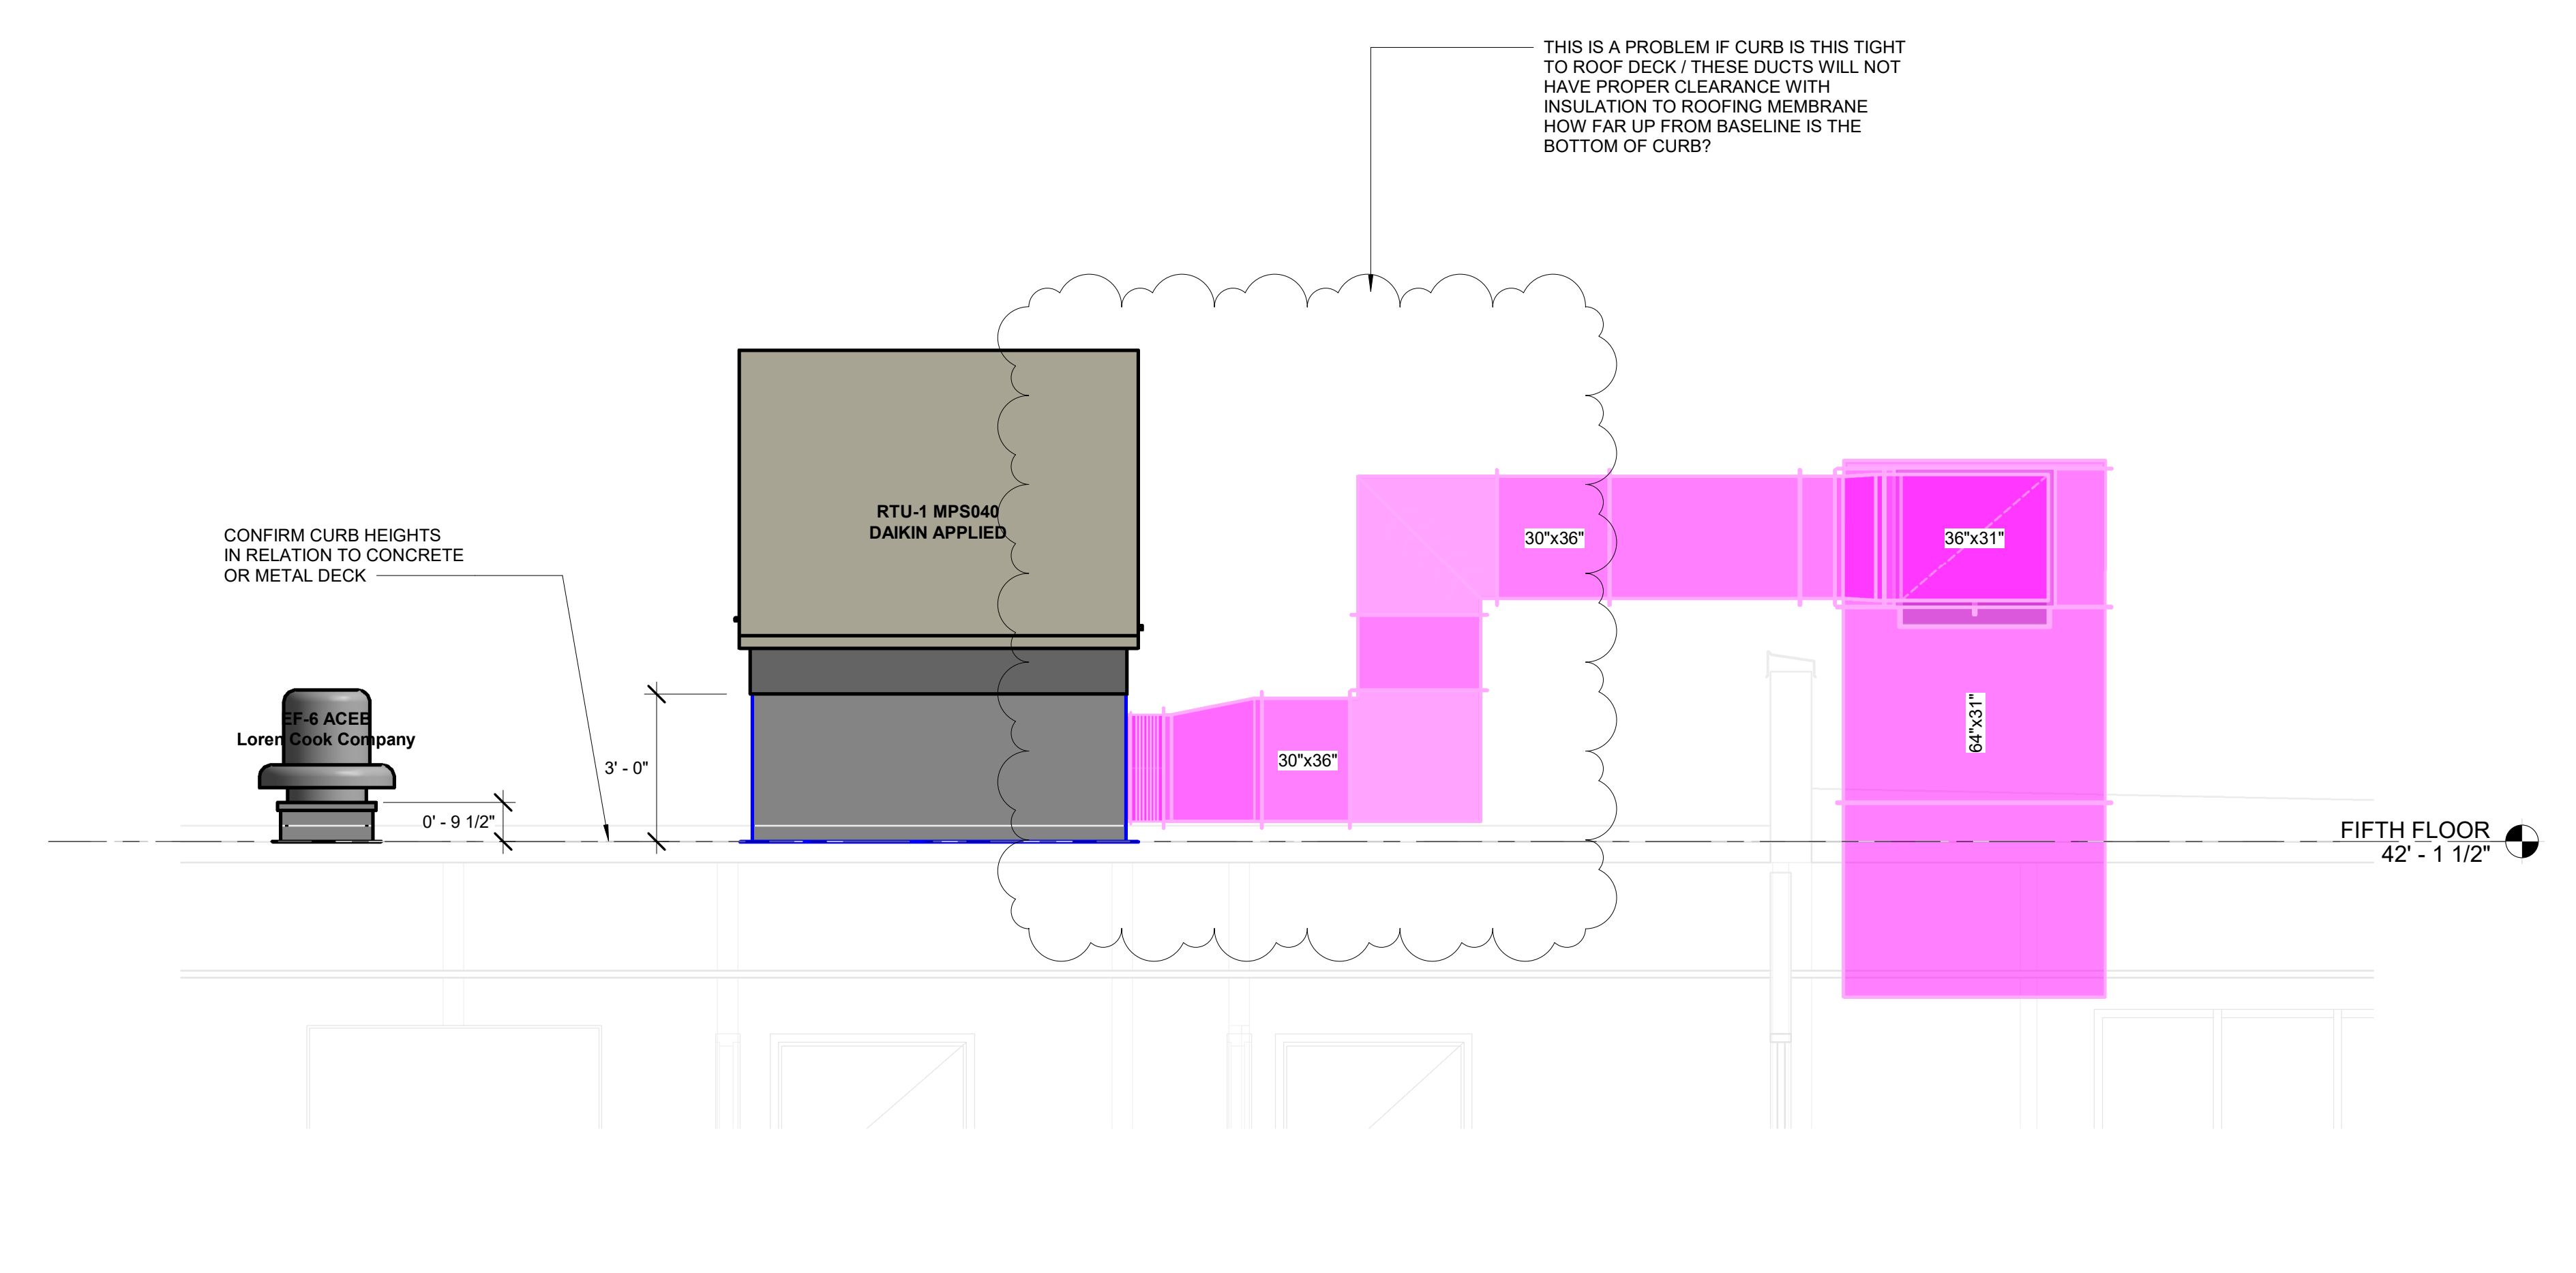


2 Section 16
3/8" = 1'-0"

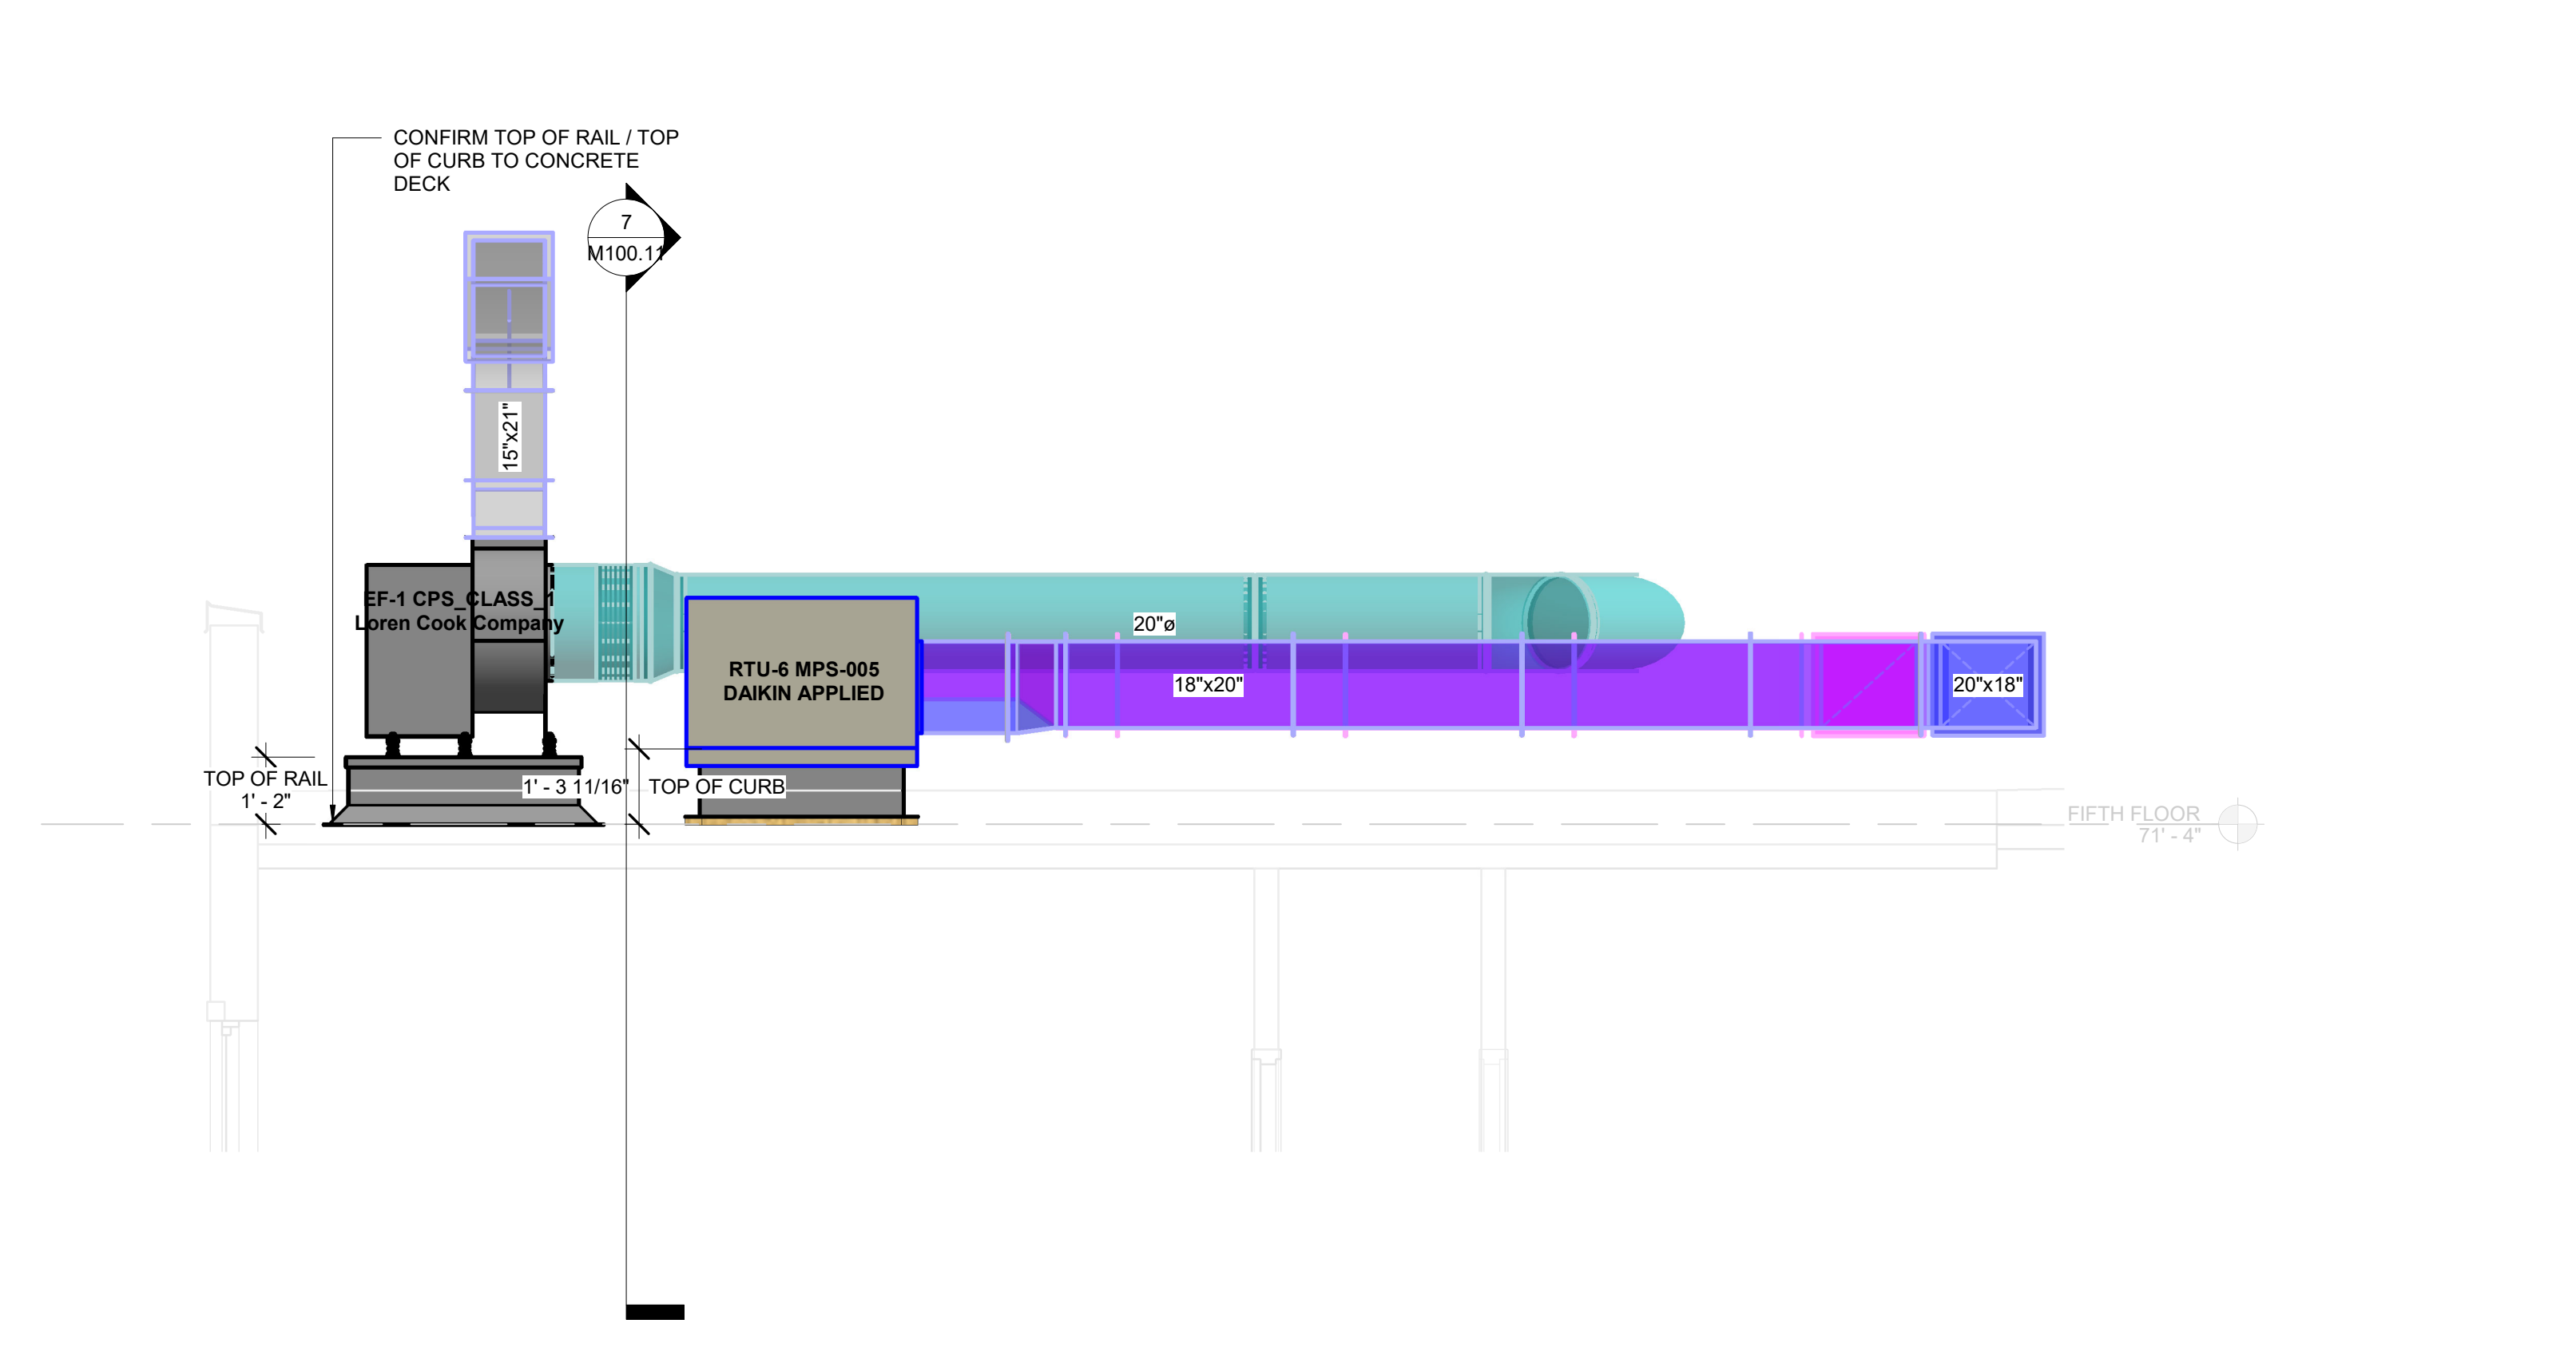

6 Section 17
3/8" = 1'-0"

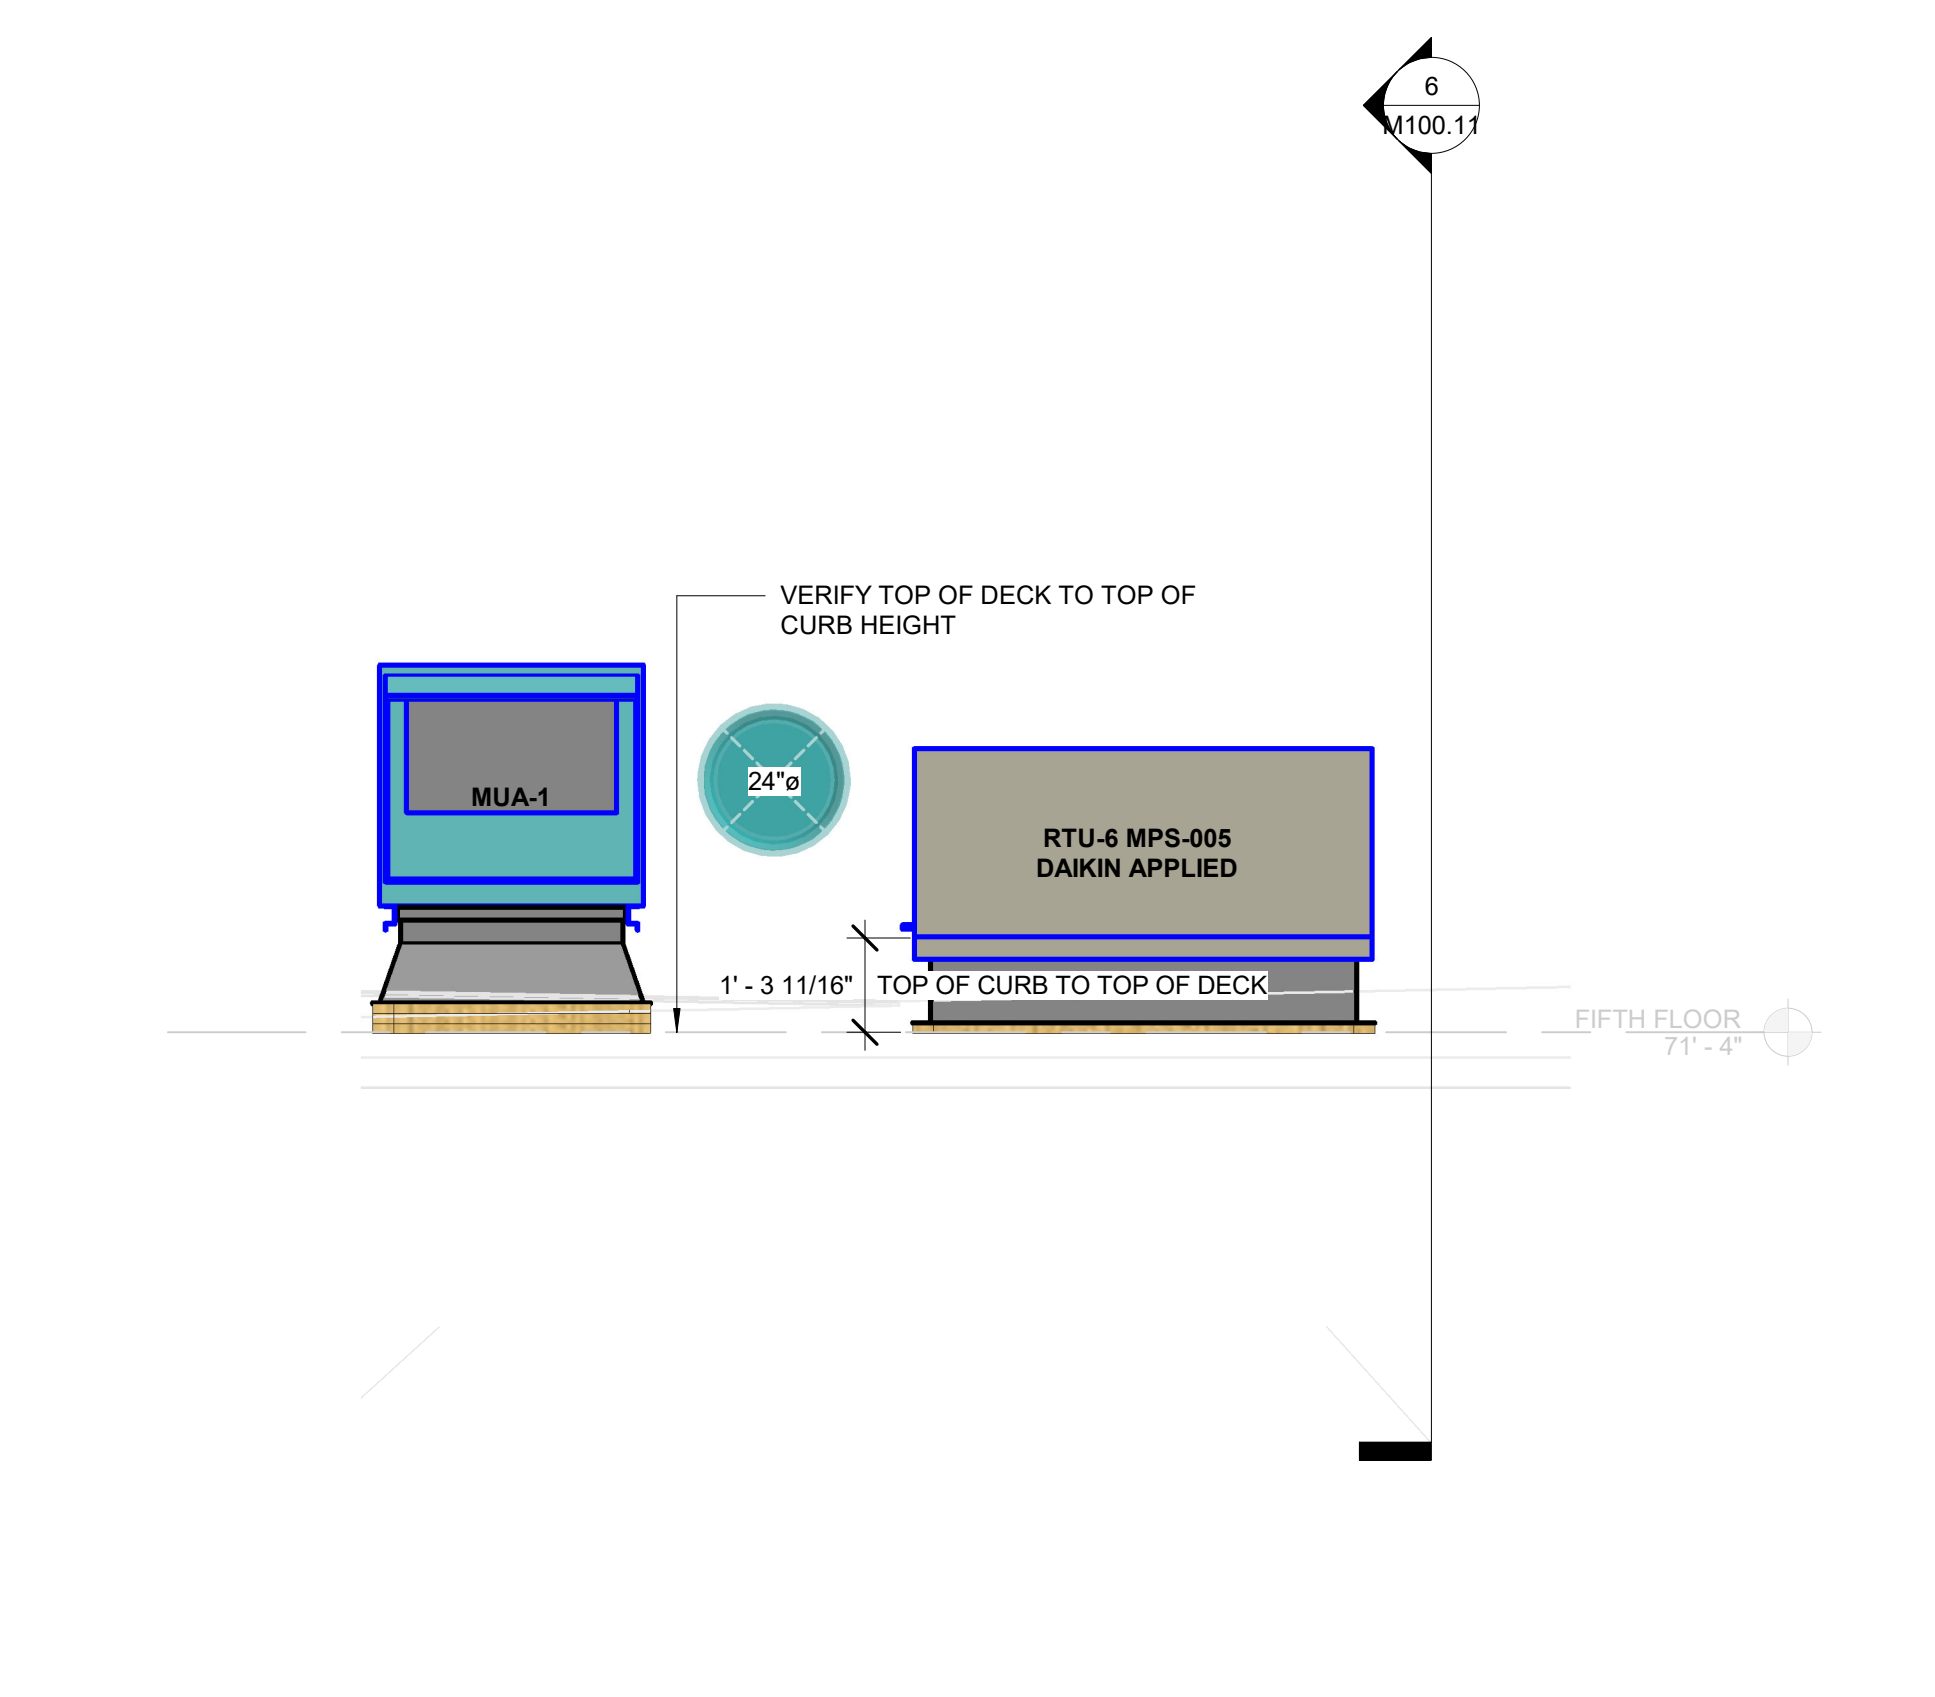

7 Section 18
3/8" = 1'-0"

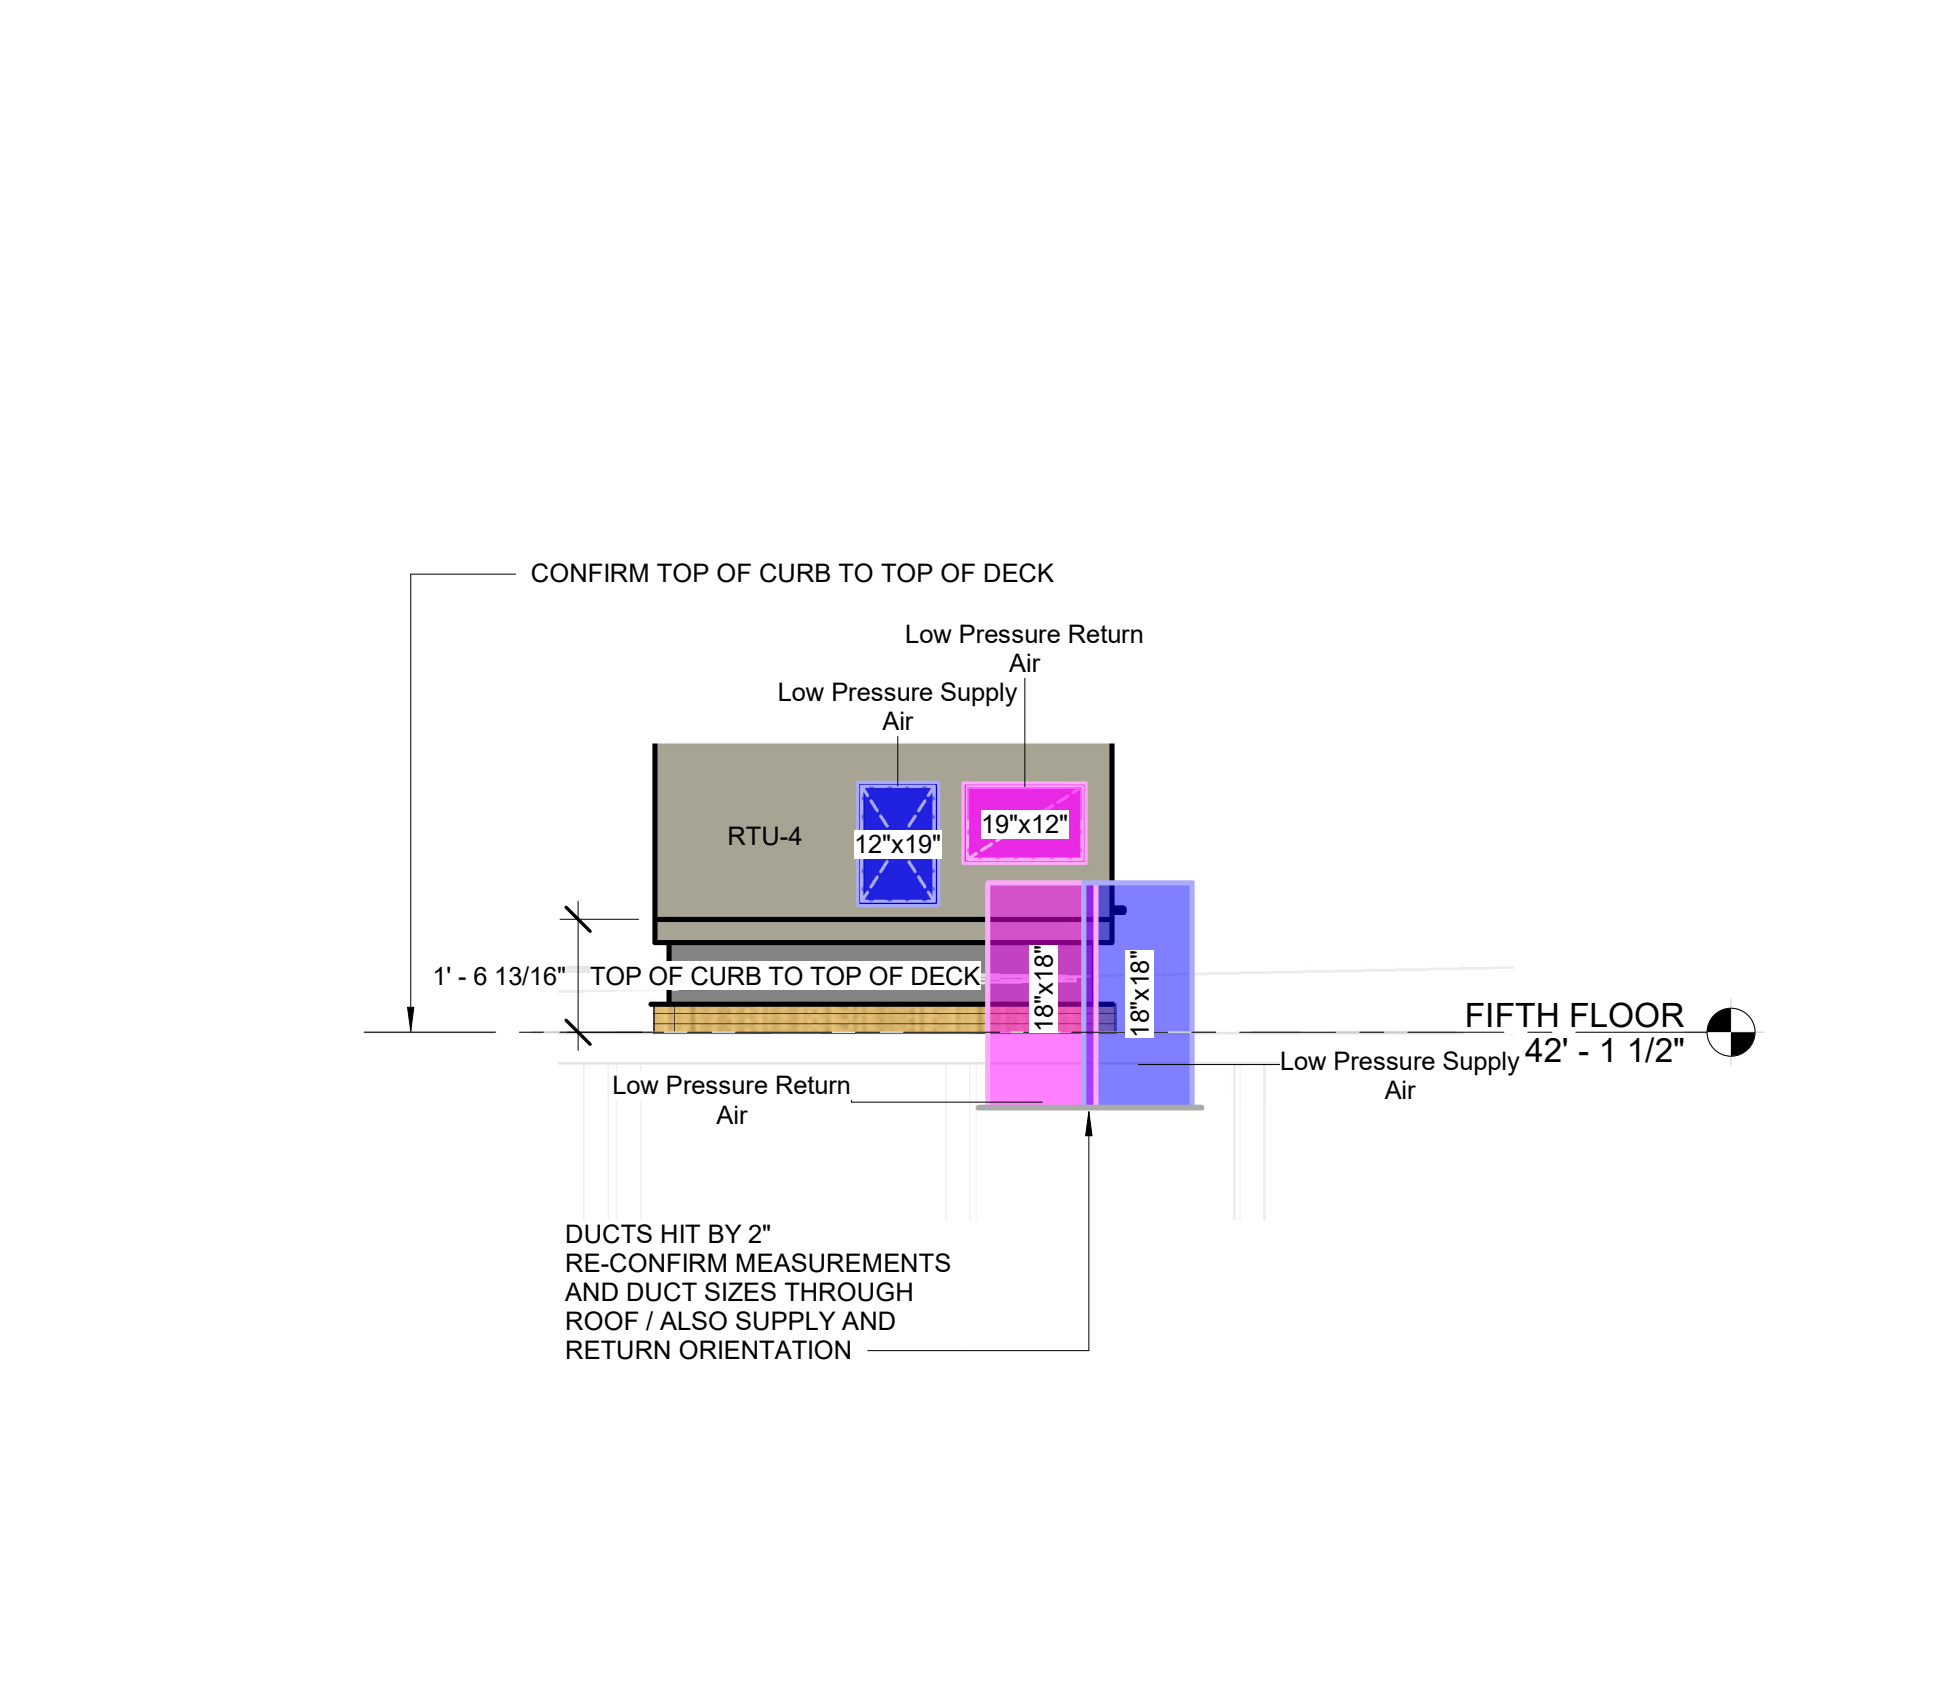

8 Section 19
3/8" = 1'-0"

No.	Description	Date
1	Revision 1	Date 1

BRIDGEPORT RESCUE MISSION, INC.
 JOEL SMILOW CARE CENTER
 725 PARK AVENUE
 BRIDGEPORT, CT 06604

ROOF SECTIONS

Project Number 4929
 Date 1/31/2020
 Drawn By Author
 Checked By Checker