

NOTE:

1. ALL TERMINAL EQUIPMENT TO LINE UP WITH GRID. THE DIMENSIONS SHOWN ARE APPROXIMATE.
2. DSB LINE DESIGN PIPING LAYOUT SUBMITTAL. FOR PIPING LENGTHS AND SIZES ARE THE GOVERNING DOCUMENT FOR THE PIPING INSTALLATION. REFER TO DSB SUBMITTAL FOR CONFLICT RESOLUTION.
3. ALL EQUIPMENT SUSPENDED FROM BAR JOIST STEEL MUST HAVE THE ATTACHMENT FIXED ON THE TOP CORD OF SAID STRUCTURAL ELEMENT.

No.	Description	Date
1	ISSUED FOR CONSTR.	10/24/2022


Owner

Hudson Montessori School

44A Shelter Rock Rd
 Danbury, CT 06810

FIRST FLOOR PLAN

Project Number	10254
Date	10/18/2022
Drawn By	TH
Checked By	TH JM
Scale	1/8" = 1'-0"

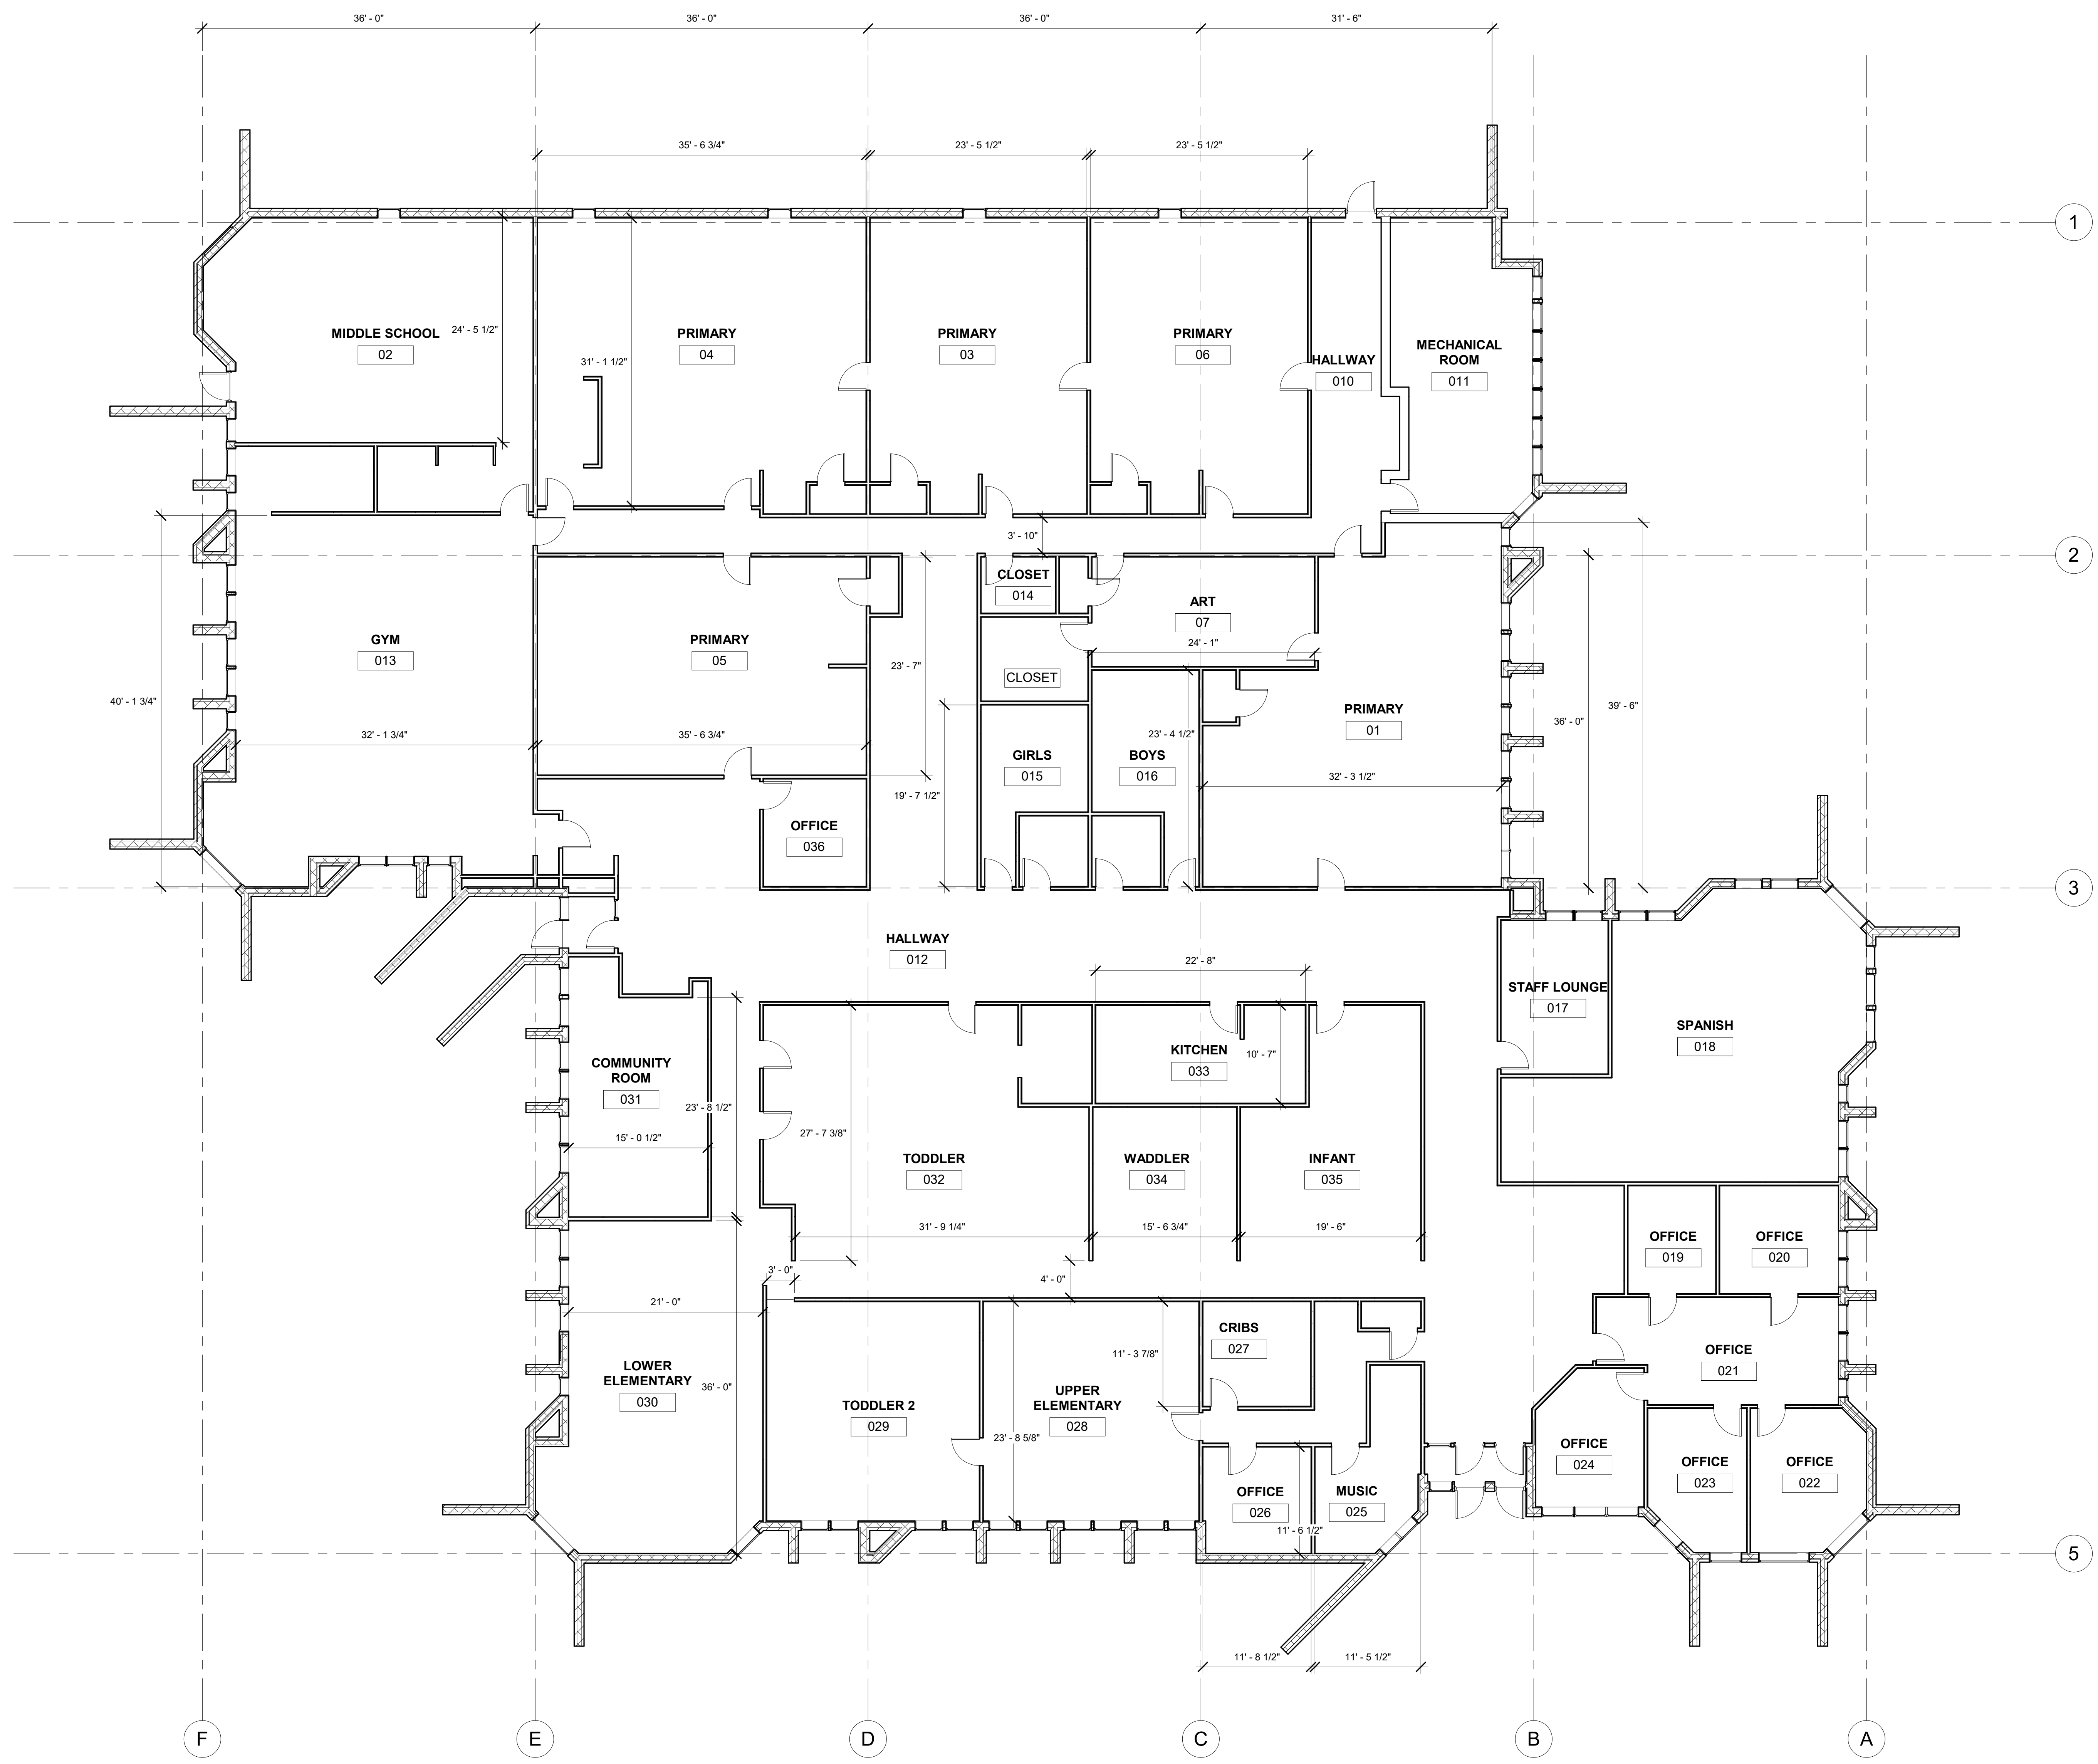


① Level 1 Room Names
 1/8" = 1'-0"

09/26/2023 4:27:33 PM

NOTE:

1. ALL TERMINAL EQUIPMENT TO LINE UP WITH GRID. THE DIMENSIONS SHOWN ARE APPROXIMATE.
2. DSS LINE DESIGN PIPING LAYOUT SUBMITTAL. FOR PIPING LENGTHS AND SIZES ARE THE GOVERNING DOCUMENT FOR THE PIPING INSTALLATION. REFER TO DSS SUBMITTAL FOR CONFLICT RESOLUTION.
3. ALL EQUIPMENT SUSPENDED FROM BAR JOIST STEEL MUST HAVE THE ATTACHMENT FIXED ON THE TOP CORD OF SAID STRUCTURAL ELEMENT.

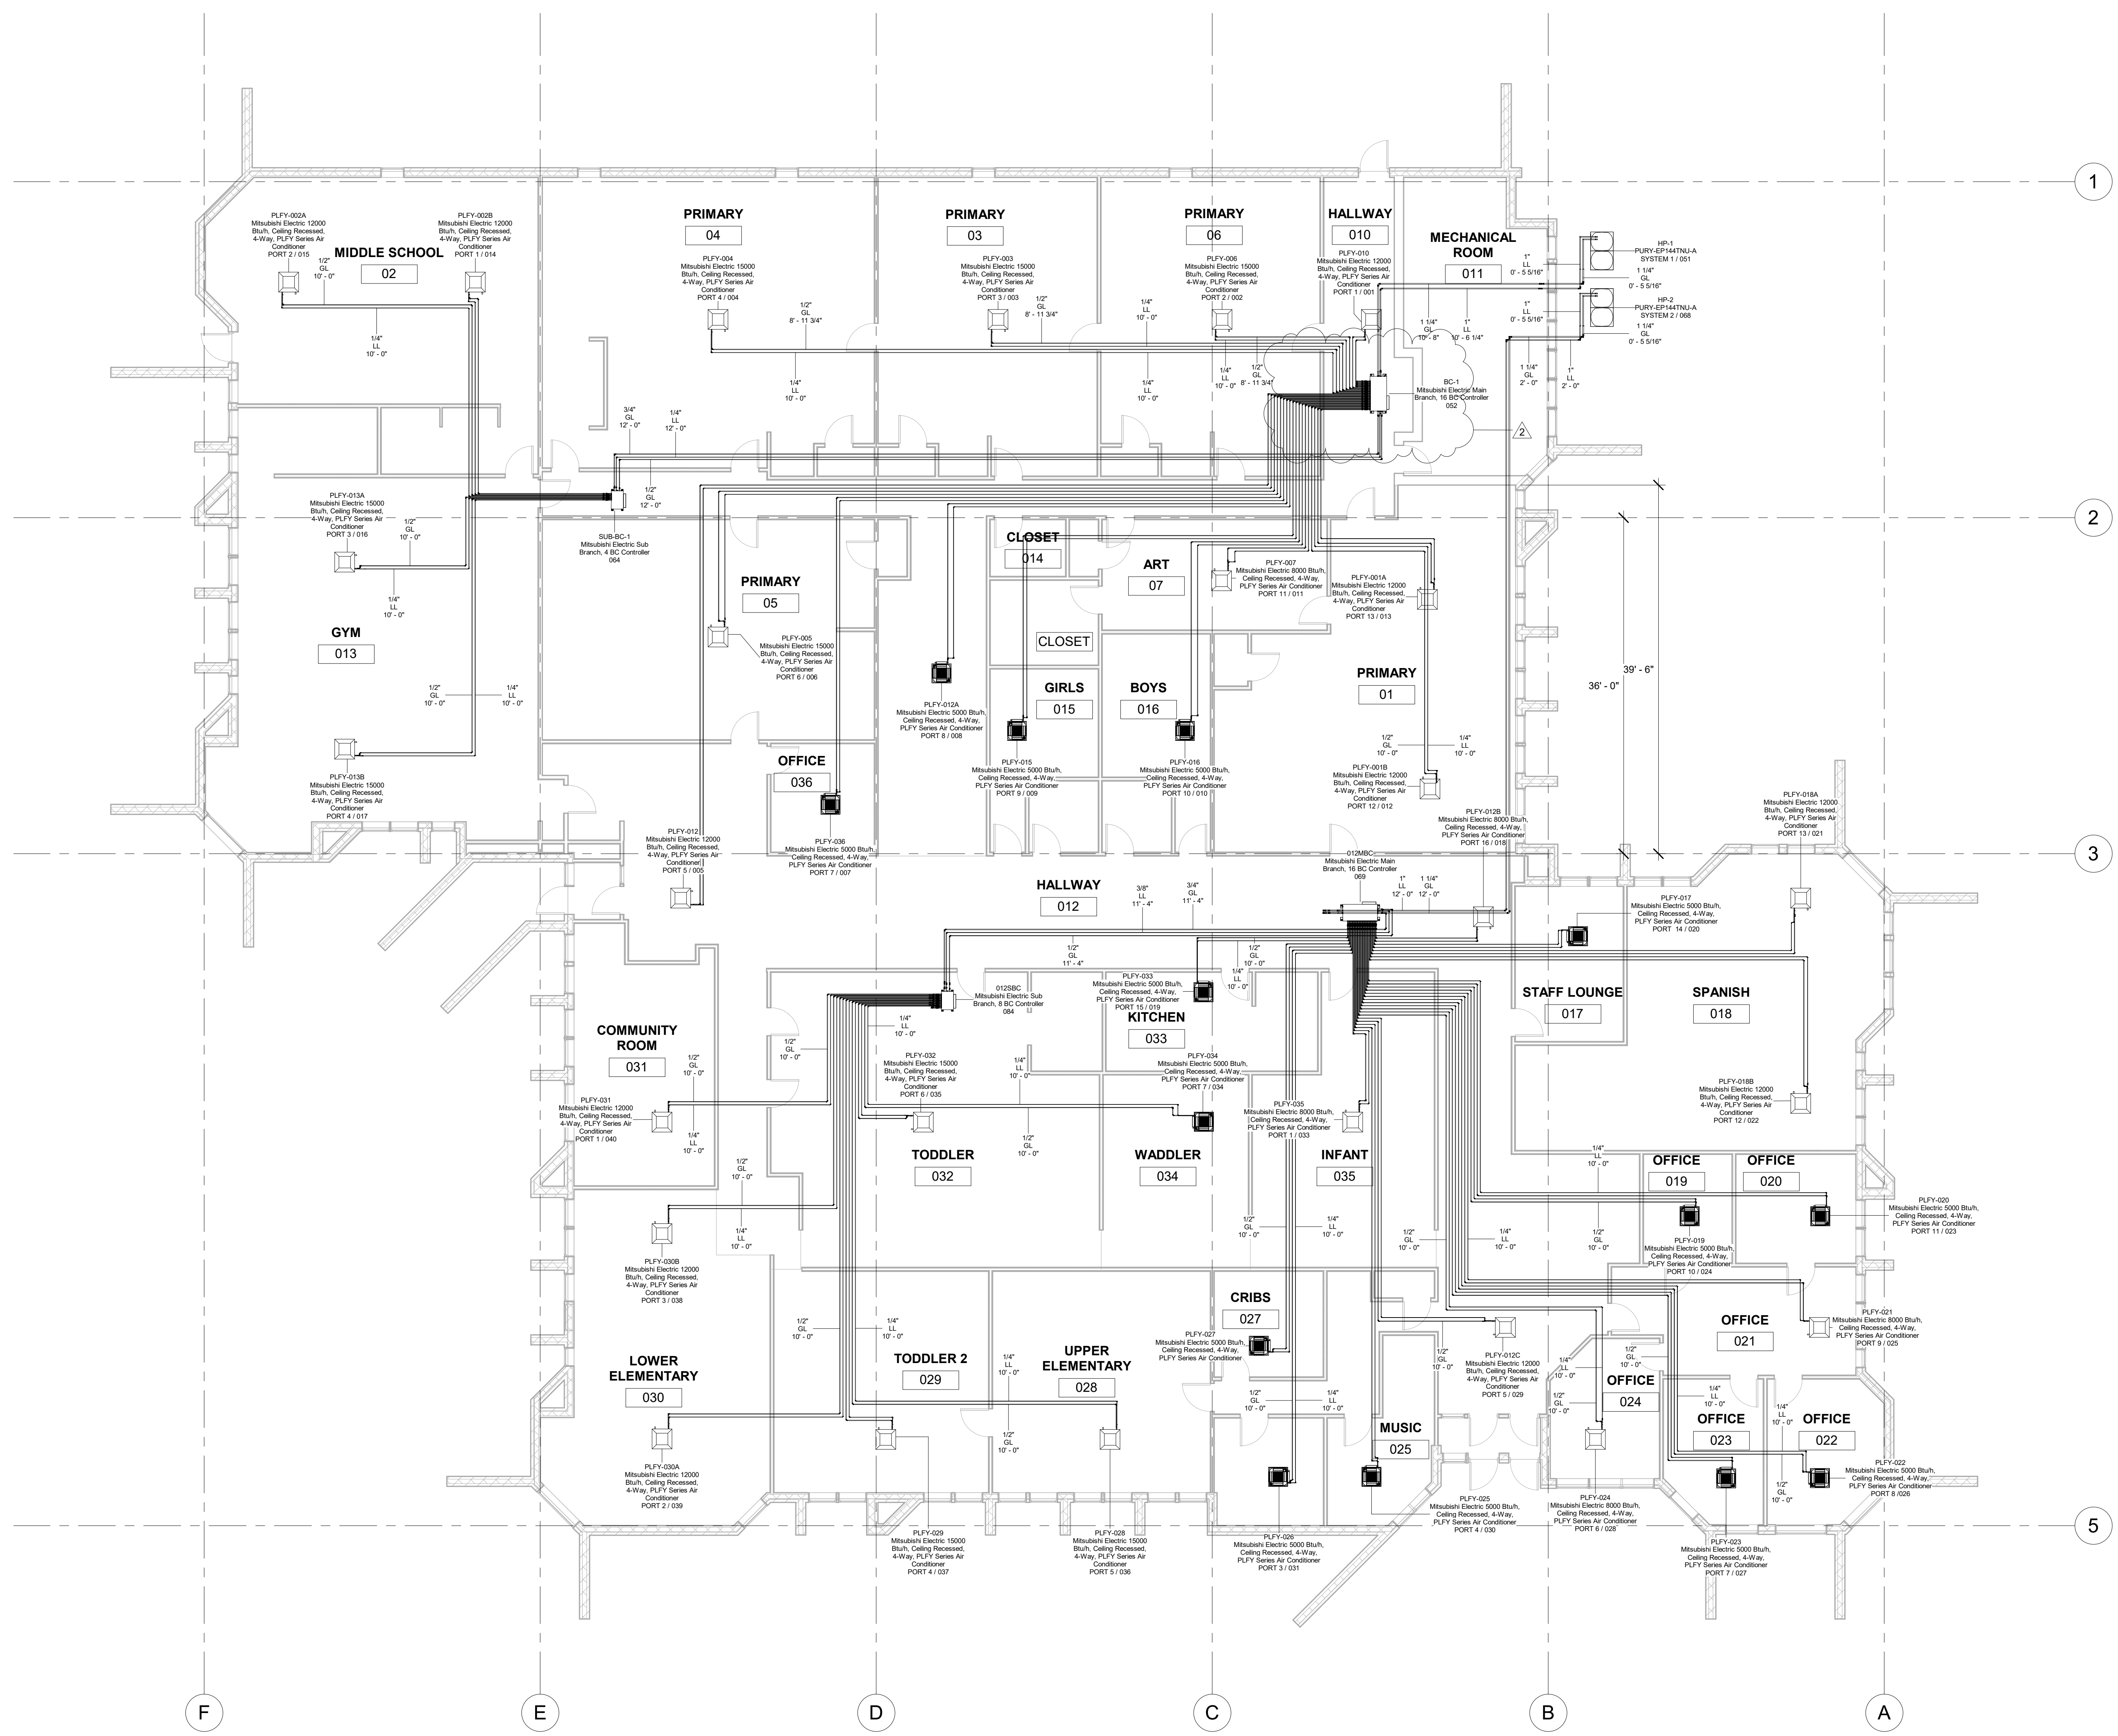

No.	Description	Date
1	ISSUED FOR CONSTR.	10/24/2022
2	MOVE BC-1	10/25/2022
3	AS-BUILT	6/24/2023

Owner

Hudson Montessori School

44A Shelter Rock Rd
Danbury, CT 06810

FIRST FLOOR MECH LAYOUT


Project Number	10254
Date	10/18/2022
Drawn By	TH
Checked By	TH JM

M100.00

Scale 1/8" = 1'-0"

NOTE:

1. ALL TERMINAL EQUIPMENT TO LINE UP WITH GRID. THE DIMENSIONS SHOWN ARE APPROXIMATE.
2. DSB LINE DESIGN PIPING LAYOUT SUBMITTAL. FOR PIPING LENGTHS AND SIZES ARE THE GOVERNING DOCUMENT FOR THE PIPING INSTALLATION. REFER TO DSB SUBMITTAL FOR CONFLICT RESOLUTION.
3. ALL EQUIPMENT SUSPENDED FROM BAR JOIST STEEL MUST HAVE THE ATTACHMENT FIXED ON THE TOP CORD OF SAID STRUCTURAL ELEMENT.

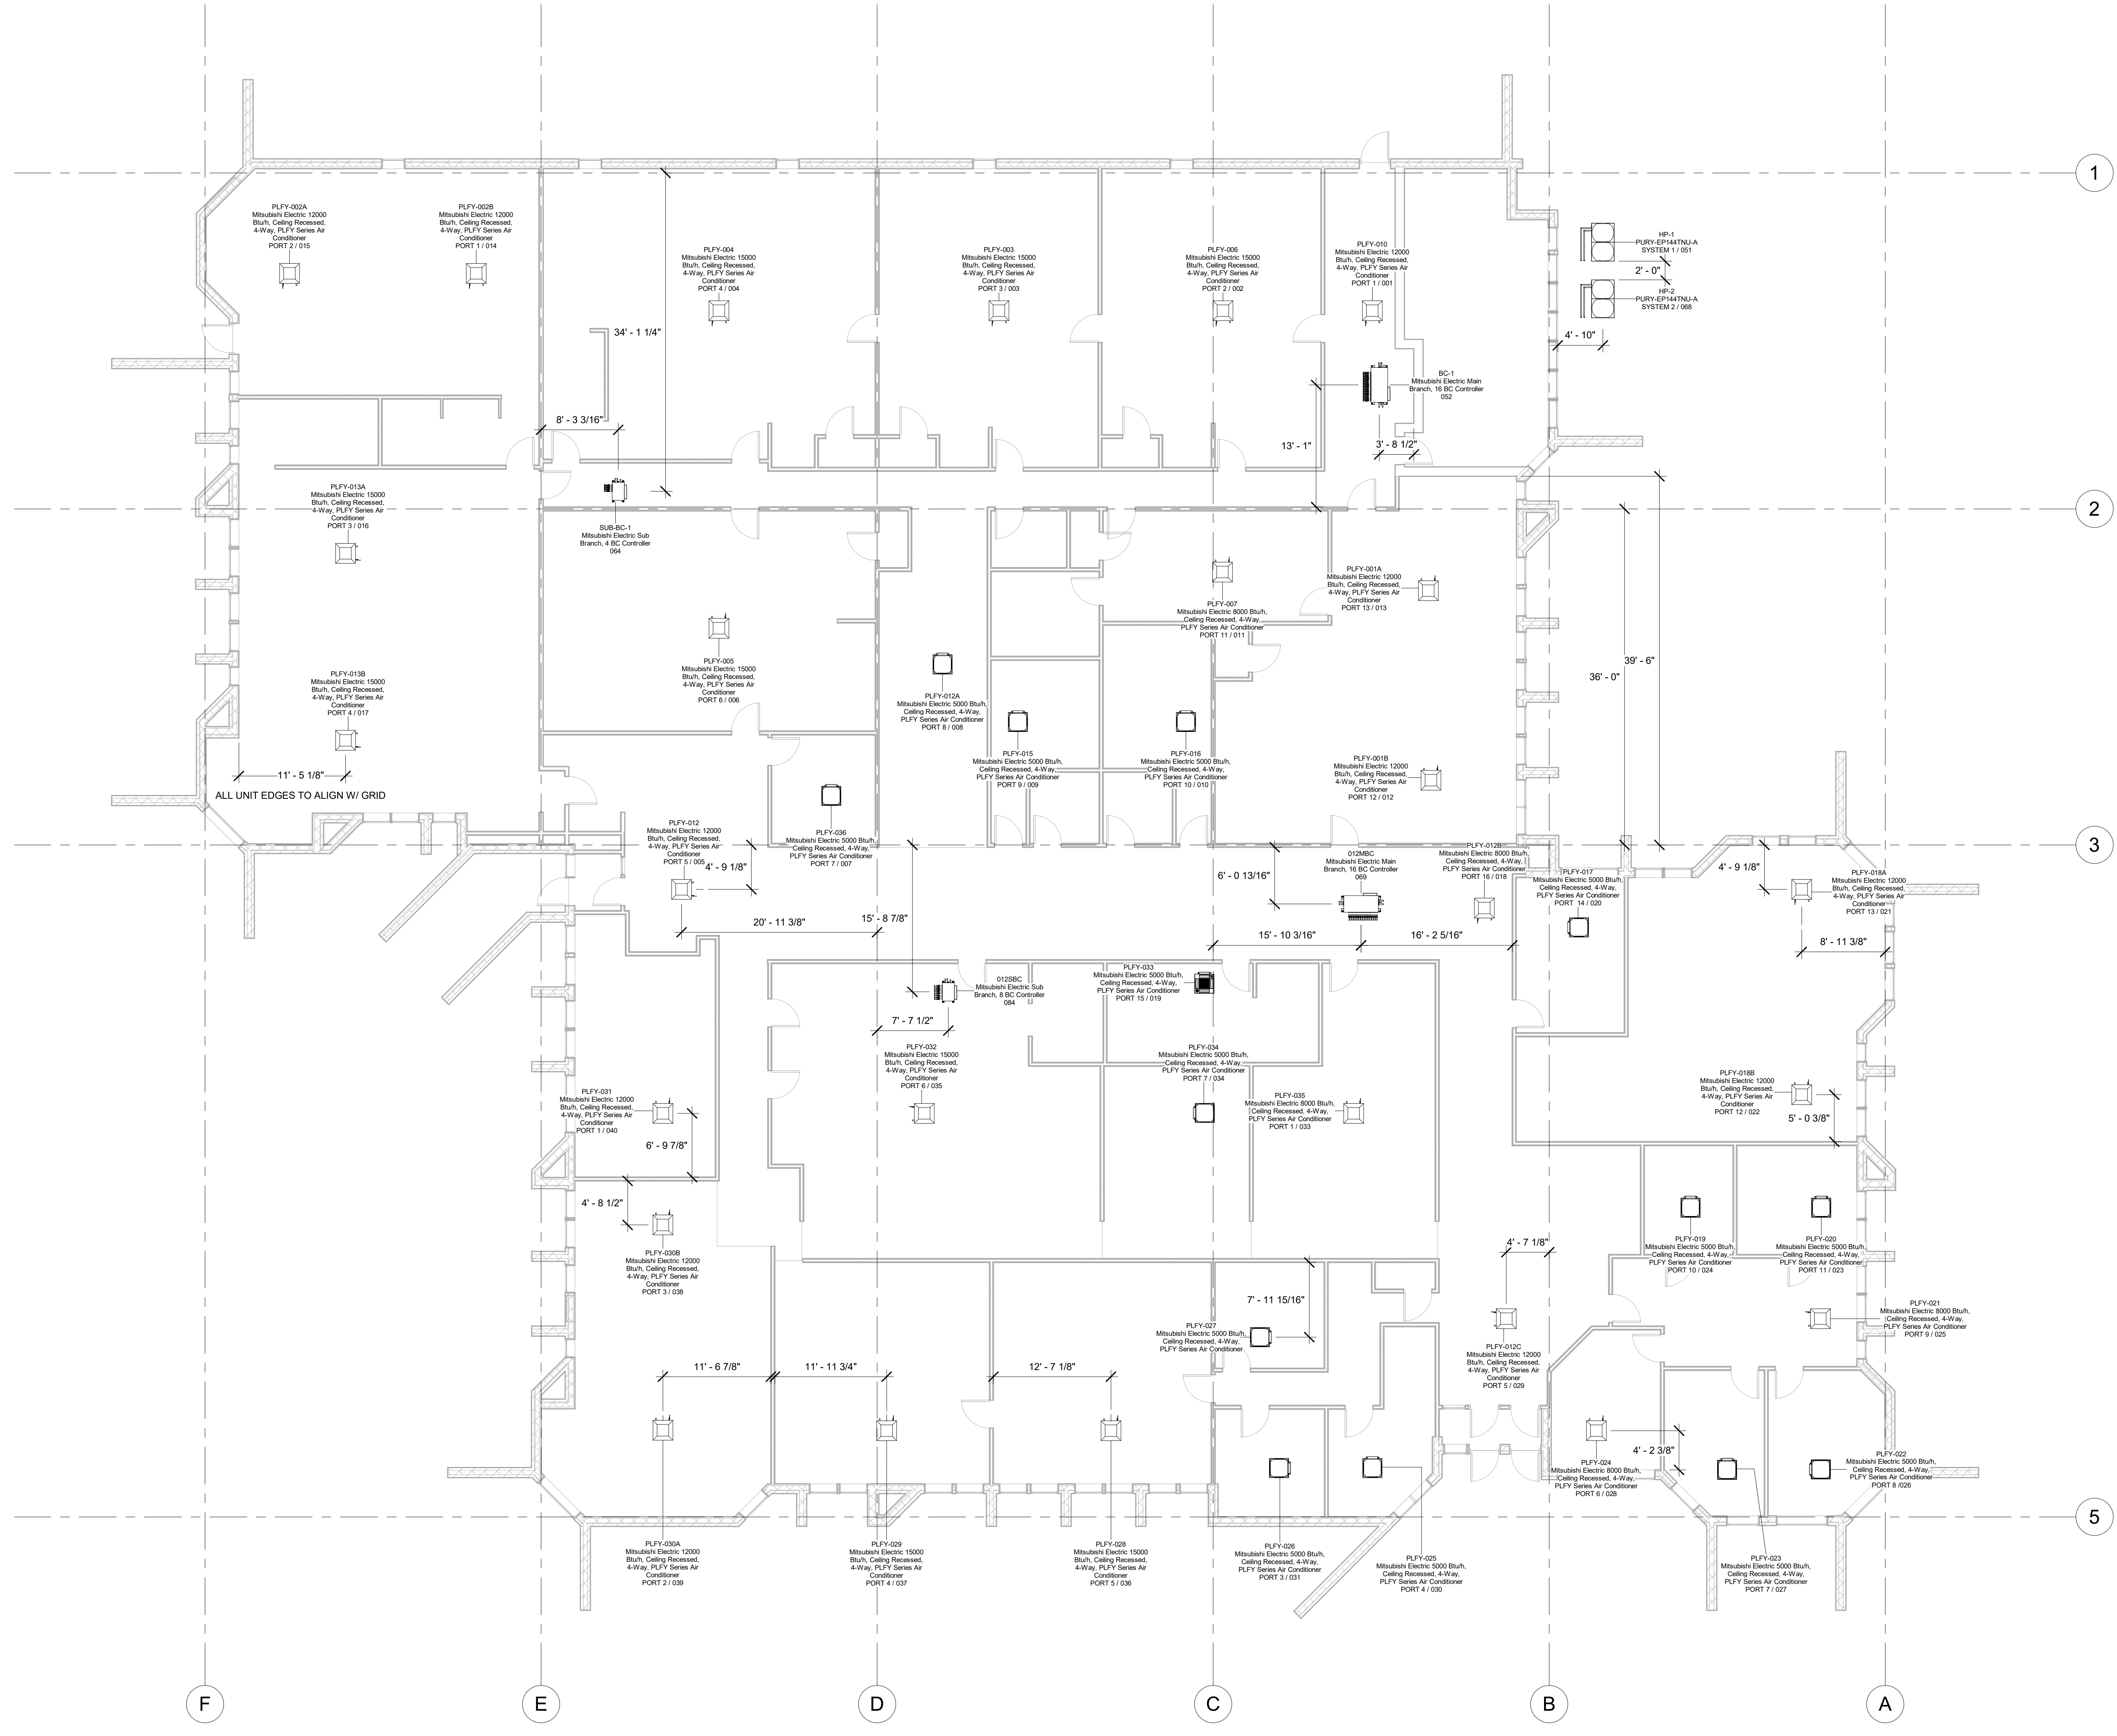

No.	Description	Date
1	ISSUED FOR CONSTR.	10/24/2022
2	AS-BUILT	6/24/2023

Owner

Hudson Montessori School

44A Shelter Rock Rd
Danbury, CT 06810

EQUIPMENT LAYOUT

Project Number	10254
Date	10/18/2022
Drawn By	TH
Checked By	TH JM
M100.02	
Scale	1/8" = 1'-0"